

GOVERNMENT OF RAJASTHAN
Rajasthan Urban Sector Development Program

BIDDING DOCUMENT

for the work of

**Construction, Commissioning and Operation of Fecal Sludge Treatment Plant of
capacity 10 m³/day at Khandela town (Rajasthan)**

Part 1– Drawings –Volume 2

Issued on: 6th August, 2018

Invitation for Bids No.: RUSDP/BMGF/04

Package No.: RUSDP/ BMGF/Khandela/01

Employer: Local Self Government Department (LSGD), Government of Rajasthan

Represented by Rajasthan Urban Infrastructure Development Project (RUIDP)

Country: India

DRAWING LIST

SI No.	Drawing Name	Drawing No.
1.	Master Plan-1	BMGF/Khandela/D-MP-1
2.	Hydraulic Profile Diagram	BBMGF/Khandela/D-HP-2
3.	Screen and Grit Chamber	BMGF/Khandela/D-SC-3
4.	Planted Drying Bed	BMGF/Khandela/D-PDB-4 BMGF/Khandela/D-PDB-5
5.	Integrated Settler & Anaerobic Filter	BMGF/Khandela/D-ISAF-6 BMGF/Khandela/D-ISAF-7
6.	Planted Gravel Filter	BMGF/Khandela/D-PGF-8
7.	Polishing Pond	BMGF/Khandela/D-PP-9 BMGF/Khandela/D-PP-10
8.	Operator Room	BMGF/Khandela/D-OR-11
9.	Guard Room	BMGF/Khandela/D-GR-12
10.	Sludge Storage Yard	BMGF/Khandela/D-SSY-13
11.	Road Section & Outfall Structure	BMGF/Khandela/D-ROAD-14
12.	Ramp	BMGF/Khandela/D-RAMP-15
13.	Storm Water Drain Plan	BMGF/Khandela/D-SWD-16
14.	Storm Water Drain	BMGF/Khandela/D-SWD-17
15.	Retaining Wall	BMGF/Khandela/D-RW-18
16.	Registers	BMGF/Khandela/D-REGISTER-19
17.	Site Contour Map	BMGF/Khandela/D-CONTOUR-20



DRAWING TITLE:
Faecal Sludge Treatment Plant, Khandela, Rajasthan

PROJECT:
Capacity Building Support for Innovative Sanitation Solution for Rajasthan

DRAWING NO.:
BMGF/Khandela/D-MP-1

SCALE: NTS

NOTE:
This drawing is indicative and for bidding purpose only

CLIENTS:
Rajasthan Urban Infrastructure Development
Project




CONSULTANT:
IPE Global Limited
IPE GLOBAL
Expanding Horizons. Enriching Lives.


IPE Global House
B-84, Defence Colony,
New Delhi - 110 024
Tel. +91 11 4075 5900
Email: ipe@ipeglobal.com
www.ipeglobal.com

SUB CONSULTANT:
CDD Society
Survey No.205 ,Opp.
Beedi Workers Colony,
Kommaghatta Road,
Bandemath, Kengeri
Satellite Town,
Bengaluru, Karnataka
560060




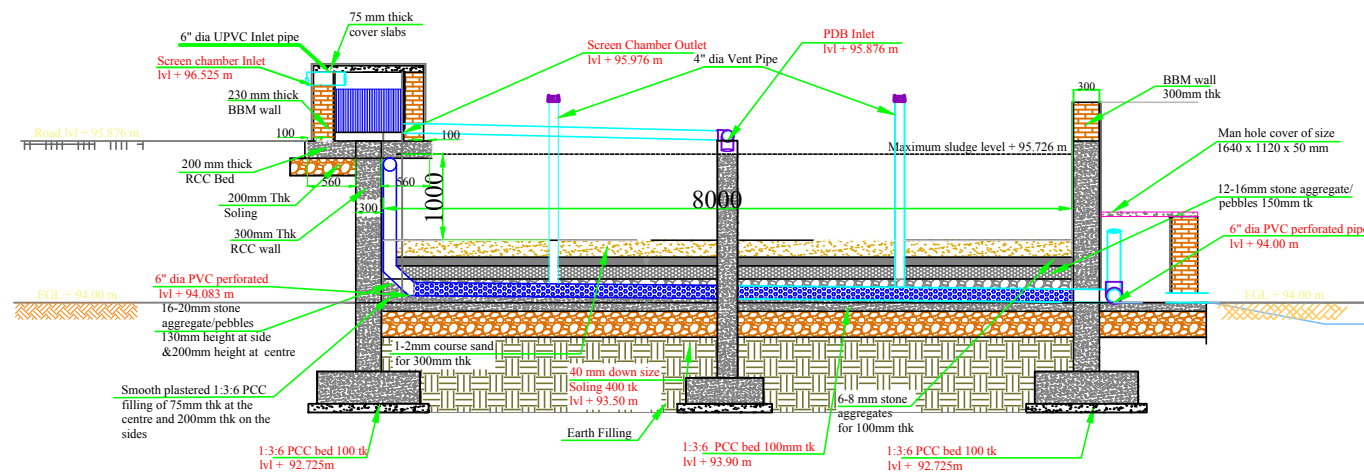


Planted Drying Bed

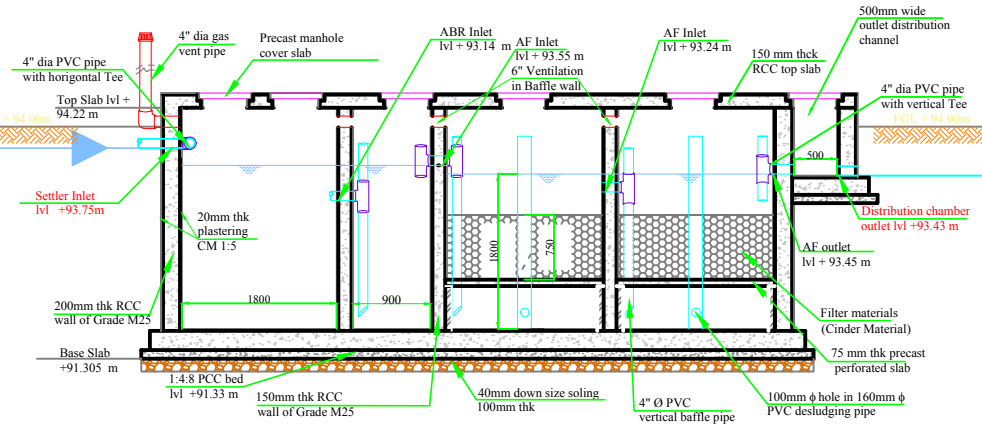

Integrated Settler and Anaerobic Filters

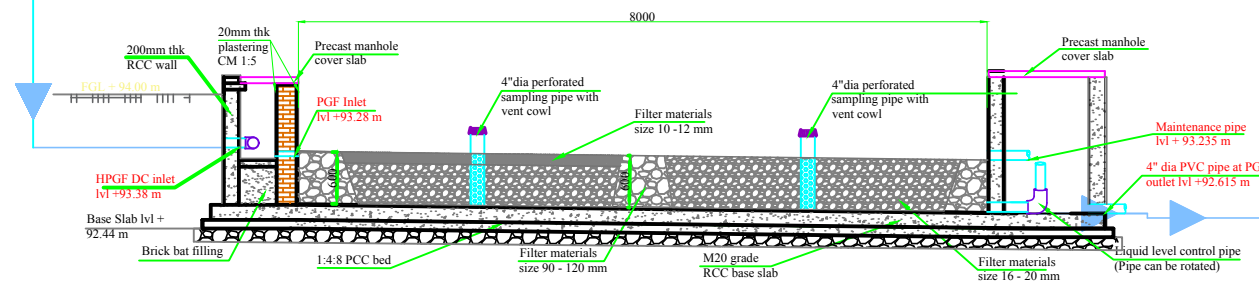

Planted Gravel Filter

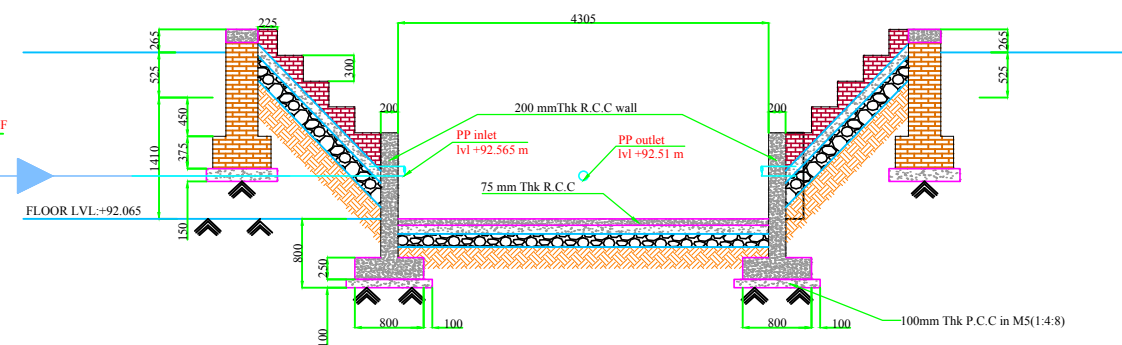

Plan of Polishing Pond

DRAWING TITLE:
Faecal Sludge Treatment Plant, Khandela, Rajasthan

PROJECT:
Capacity Building Support for Innovative Sanitation Solution for Rajasthan

DRAWING NO.:
BMGF/Khandela/D-HP-2

SCALE: NTS


NOTE:
This drawing is indicative and for bidding purpose only

CLIENTS:
Rajasthan Urban Infrastructure Development Project
RUIDP


CONSULTANT:
IPE Global Limited
IPE GLOBAL
Expanding Horizons. Enriching Lives.

IPE Global House
B-84, Defence Colony,
New Delhi - 110 024
Tel. +91 11 4075 5900
Email: ipe@ipeglobal.com
www.ipeglobal.com


SUB CONSULTANT:
CDD Society
Survey No.205 ,Opp.
Beedi Workers Colony,
Kommaghatta Road,
Bandemath, Kengeri
Satellite Town,
Bengaluru, Karnataka
560060

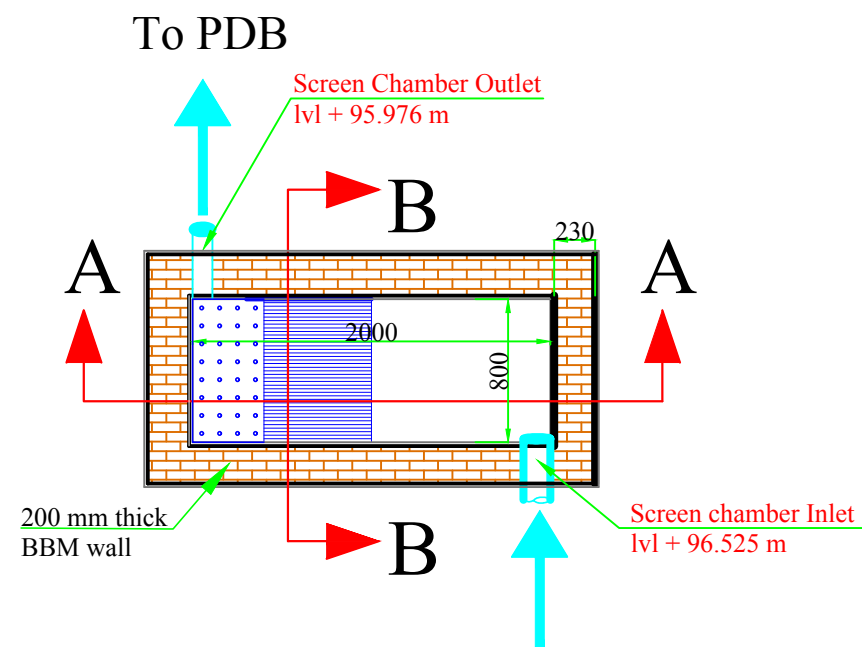


Plan of Screen Chamber

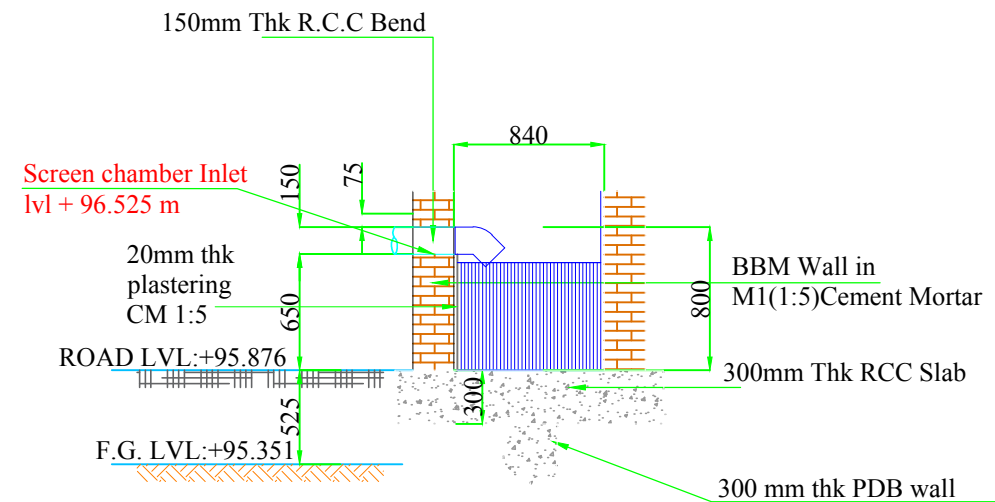


Cross Section of B-B

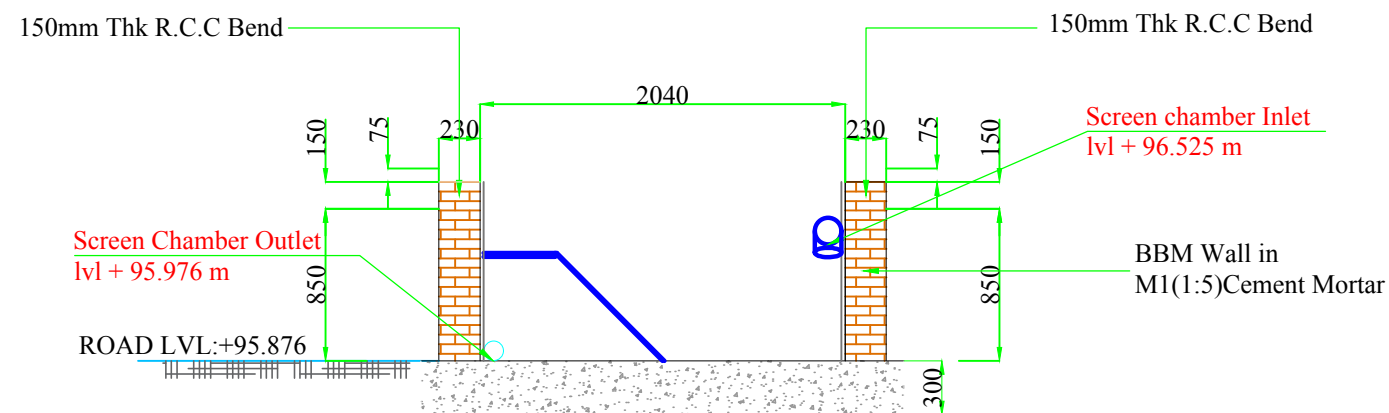

Cross Section of A-A

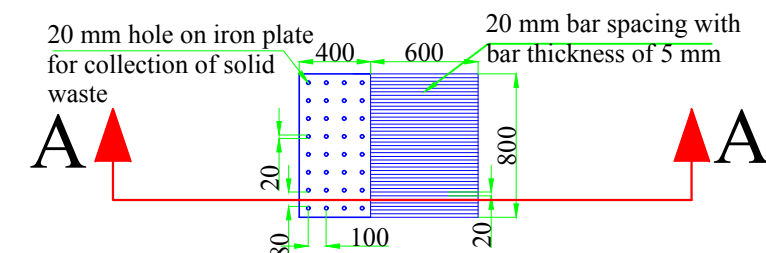

Screen Bar Details

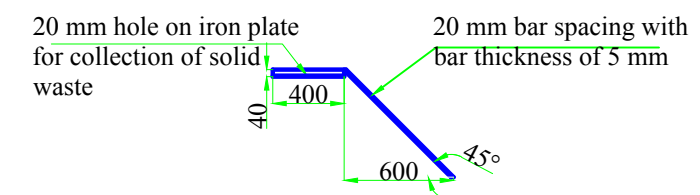

Screen cross section A-A

DRAWING TITLE:
Faecal Sludge Treatment Plant, Khandela, Rajasthan

PROJECT:
Capacity Building Support for Innovative Sanitation Solution for Rajasthan

DRAWING NO.:
BMGF/Khandela/D-SC-3

SCALE: NTS

NOTE:
This drawing is indicative and for bidding purpose only

CLIENTS:
Rajasthan Urban Infrastructure Development Project



RUIDP

CONSULTANT:
IPE Global Limited

IPE Global House
B-84, Defence Colony,
New Delhi - 110 024
Tel. +91 11 4075 5900
Email: ipe@ipeglobal.com
www.ipeglobal.com

SUB CONSULTANT:
CDD Society

Survey No.205 ,Opp.
Beedi Workers Colony,
Kommaghatta Road,
Bandemath, Kengeri
Satellite Town,
Bengaluru, Karnataka
560060

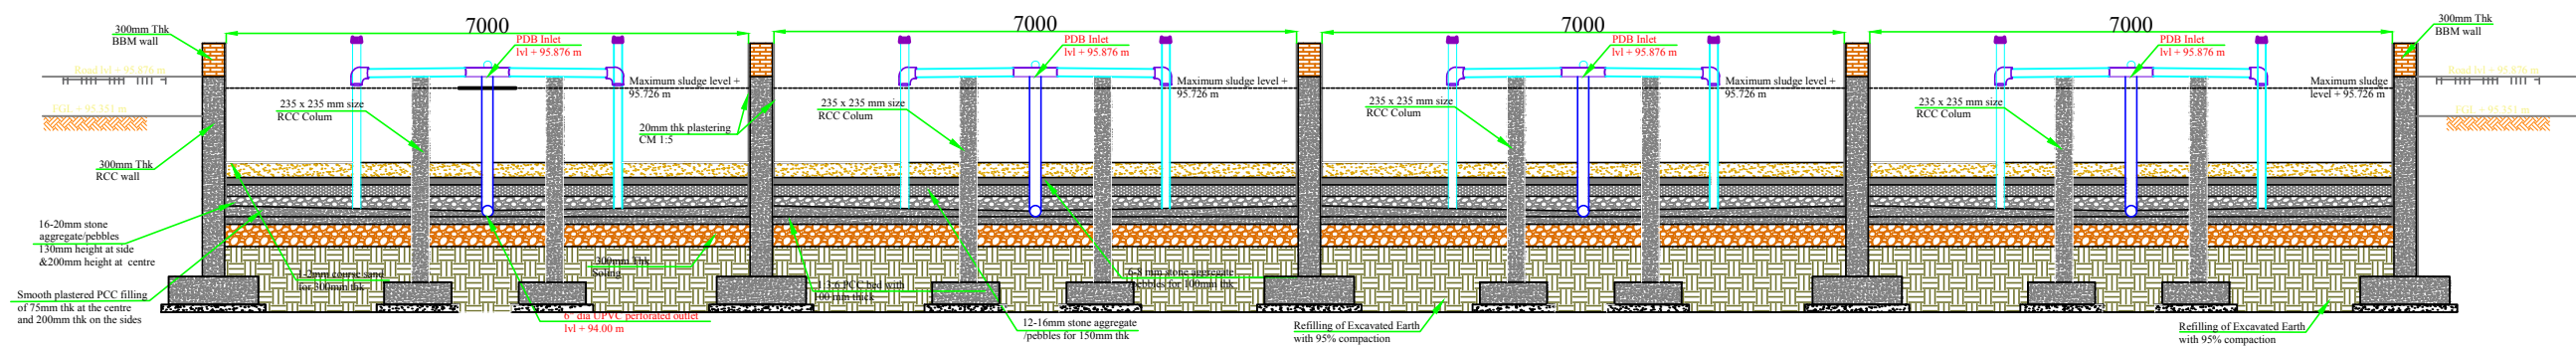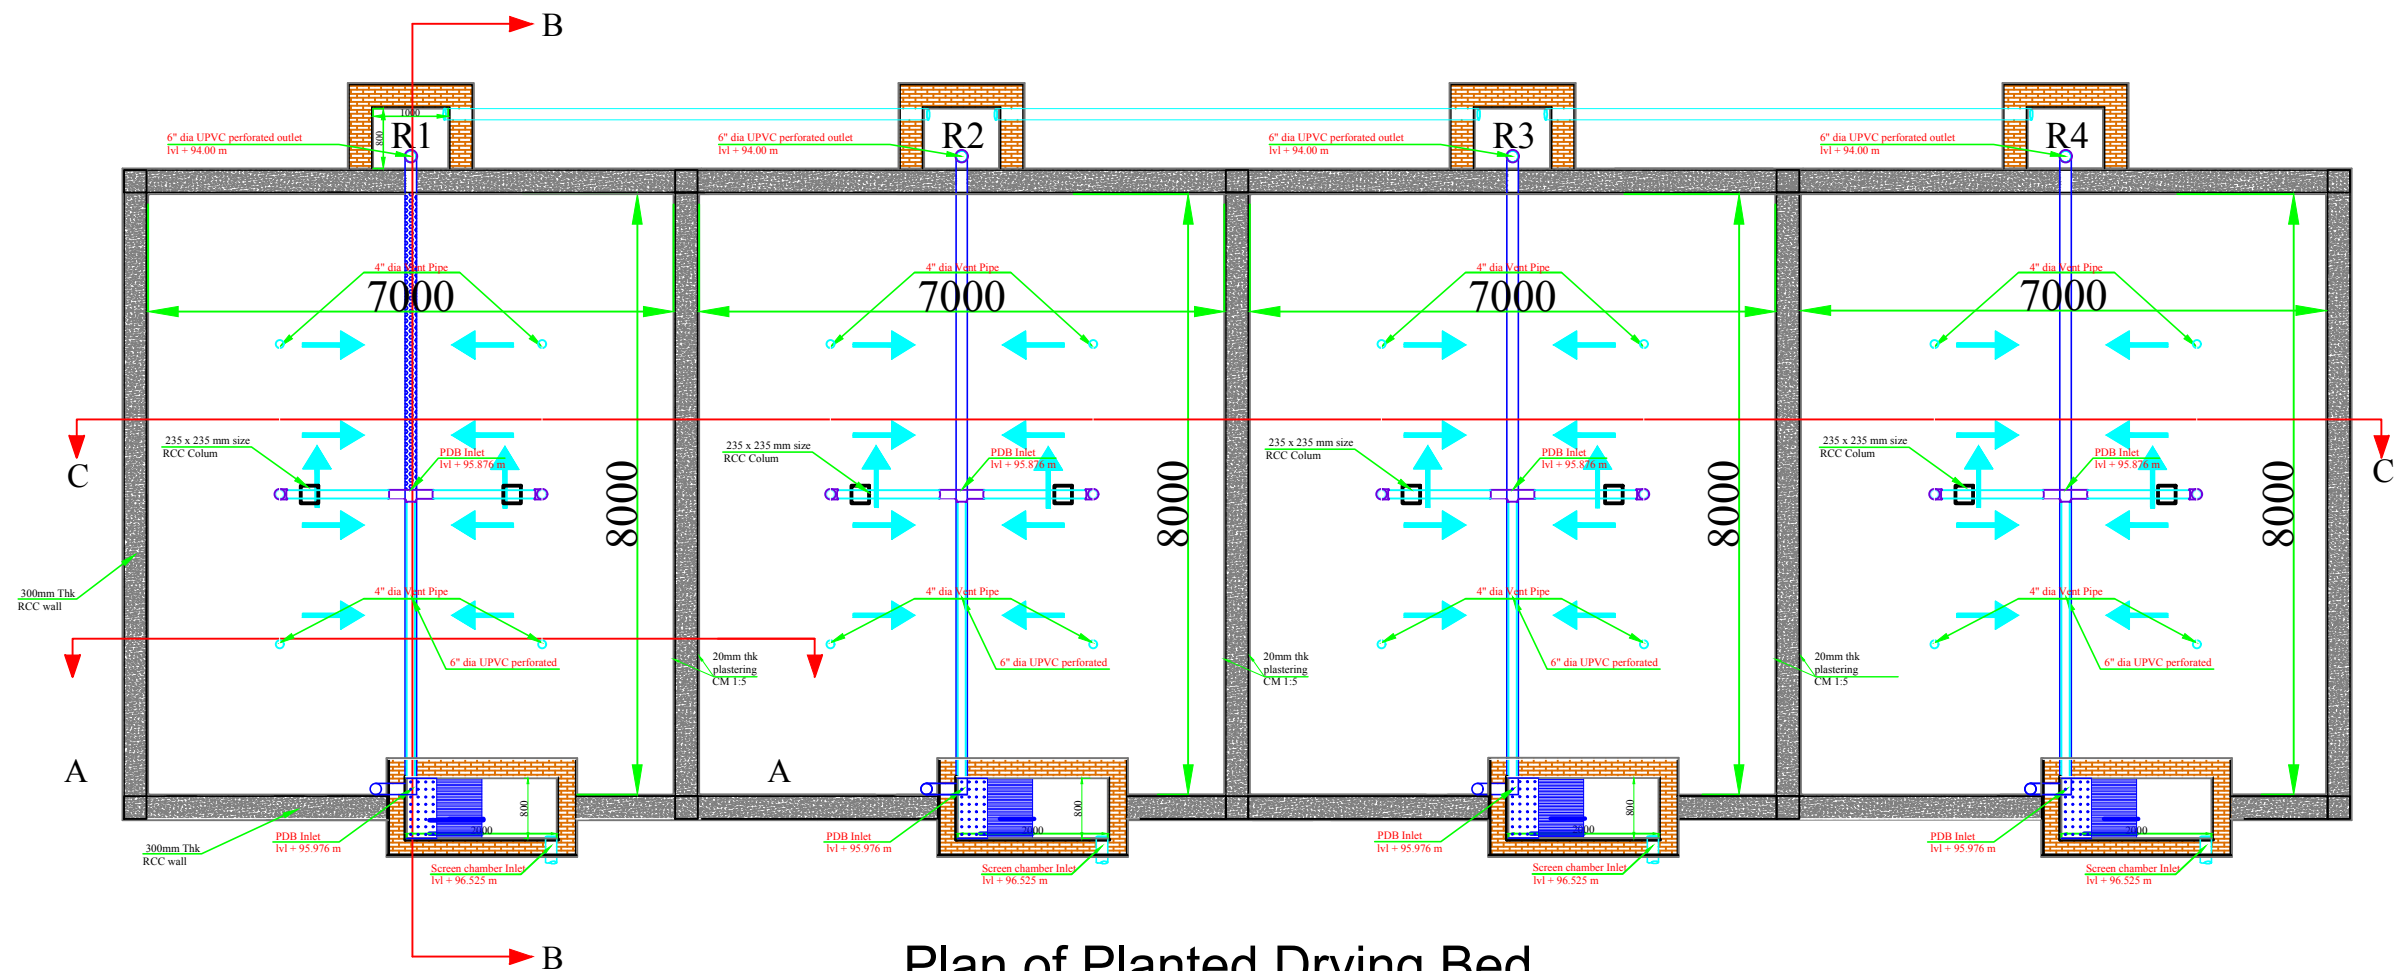

DRAWING TITLE:
Faecal Sludge Treatment Plant, Khandela, Rajasthan

PROJECT:
Capacity Building Support for Innovative Sanitation Solution for Rajasthan

DRAWING NO.:
BMGF/Khandela/D-PDB-4

SCALE: NTS


NOTE:
This drawing is indicative and for bidding purpose only

CLIENTS:
Rajasthan Urban Infrastructure Development Project
RUIDP


CONSULTANT:
IPE Global Limited
IPE GLOBAL
Expanding Horizons. Enriching Lives.

IPE Global House
B-84, Defence Colony,
New Delhi - 110 024
Tel. +91 11 4075 5900
Email: ipe@ipeglobal.com
www.ipeglobal.com

SUB CONSULTANT:
CDD Society
Survey No.205 ,Opp.
Beedi Workers Colony,
Kommaghatta Road,
Bandemath, Kengeri
Satellite Town,
Bengaluru, Karnataka
560060

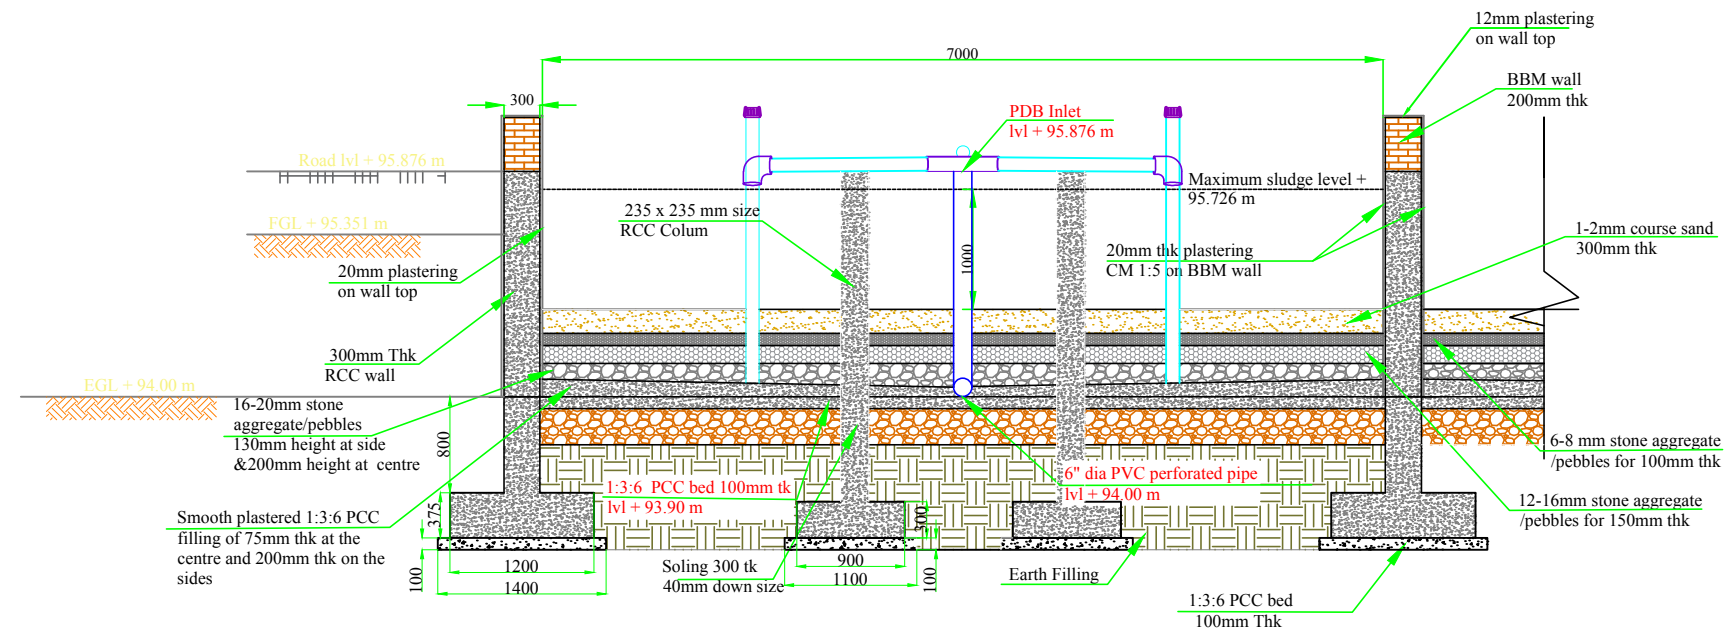

Cross Section of A-A

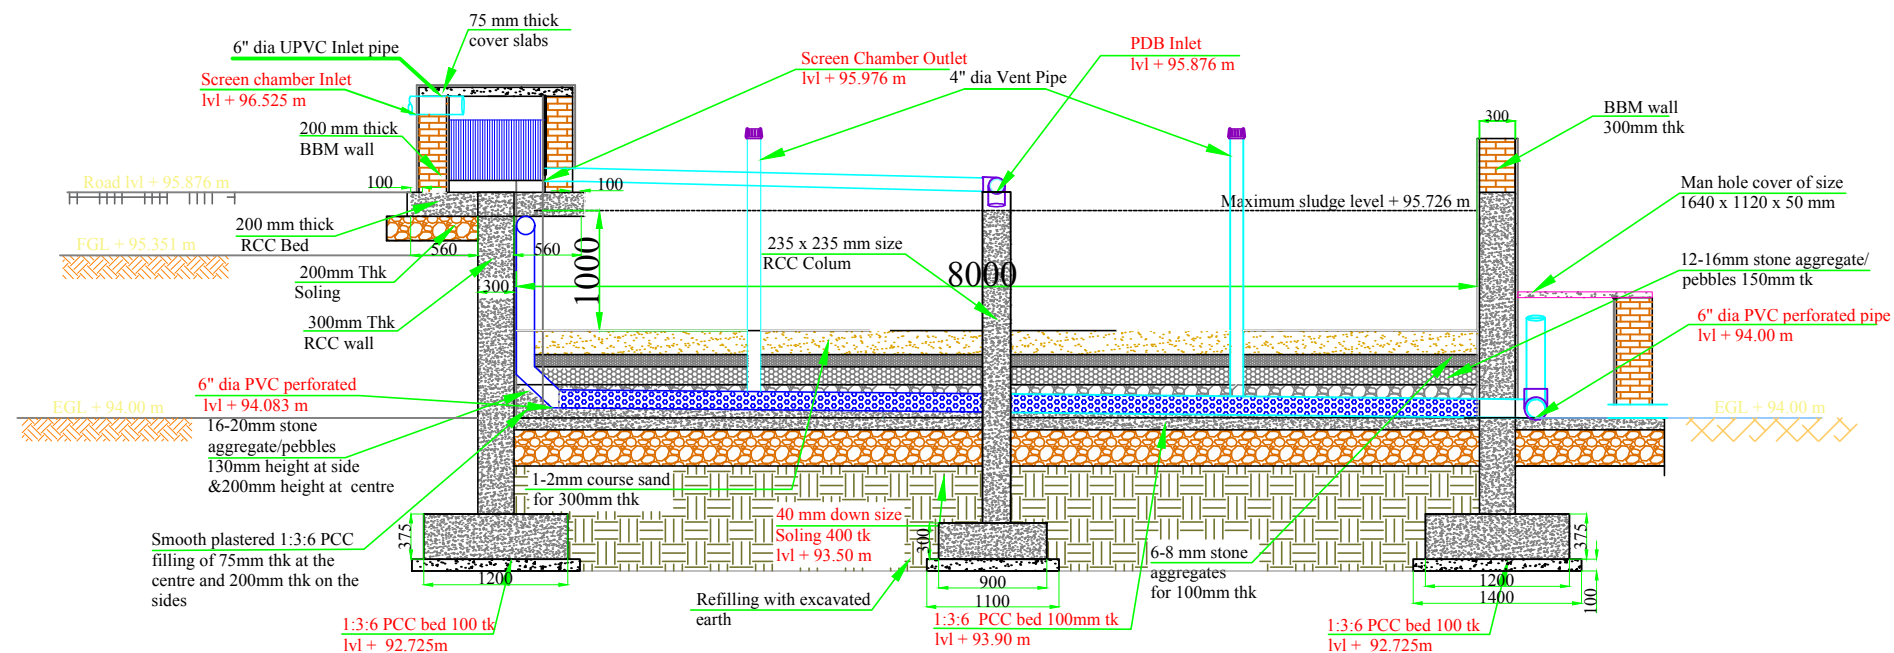

Cross Section of B-B

DRAWING TITLE:
Faecal Sludge Treatment Plant, Khandela, Rajasthan

PROJECT:
Capacity Building Support for Innovative Sanitation Solution for Rajasthan

DRAWING NO.:
BMGF/Khandela/D-PDB-5

SCALE: NTS


NOTE:
This drawing is indicative and for bidding purpose only

CLIENTS:
Rajasthan Urban Infrastructure Development Project
RUIDP


CONSULTANT:
IPE Global Limited
IPE GLOBAL
Expanding Horizons. Enriching Lives.

IPE Global House
B-84, Defence Colony,
New Delhi - 110 024
Tel. +91 11 4075 5900
Email: ipe@ipeglobal.com
www.ipeglobal.com

SUB CONSULTANT:
CDD Society
Survey No.205 ,Opp.
Beedi Workers Colony,
Kommaghatta Road,
Bandemath, Kengeri
Satellite Town,
Bengaluru, Karnataka
560060

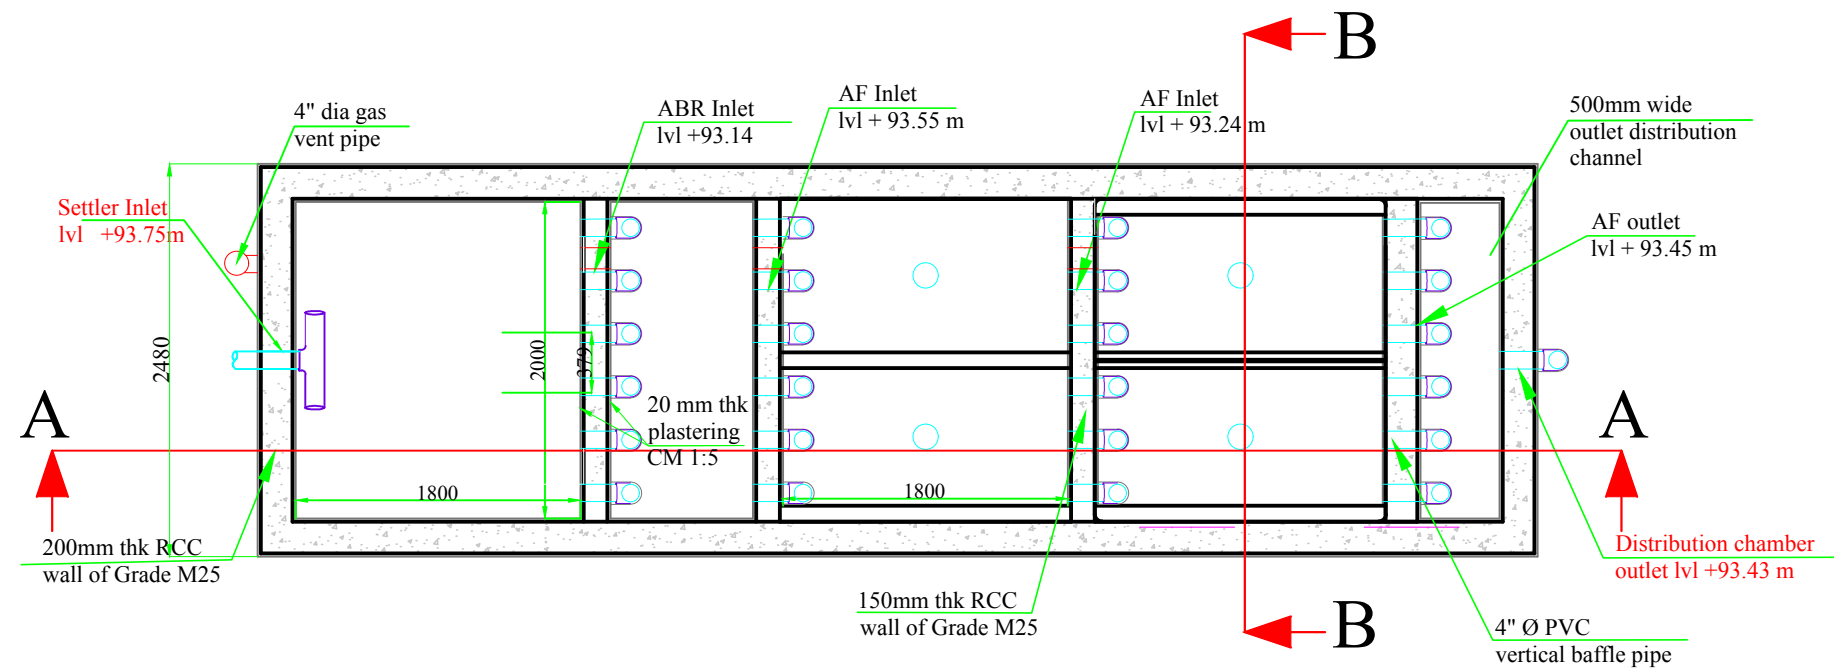

Plan of Integrated Settler and Anaerobic Filters

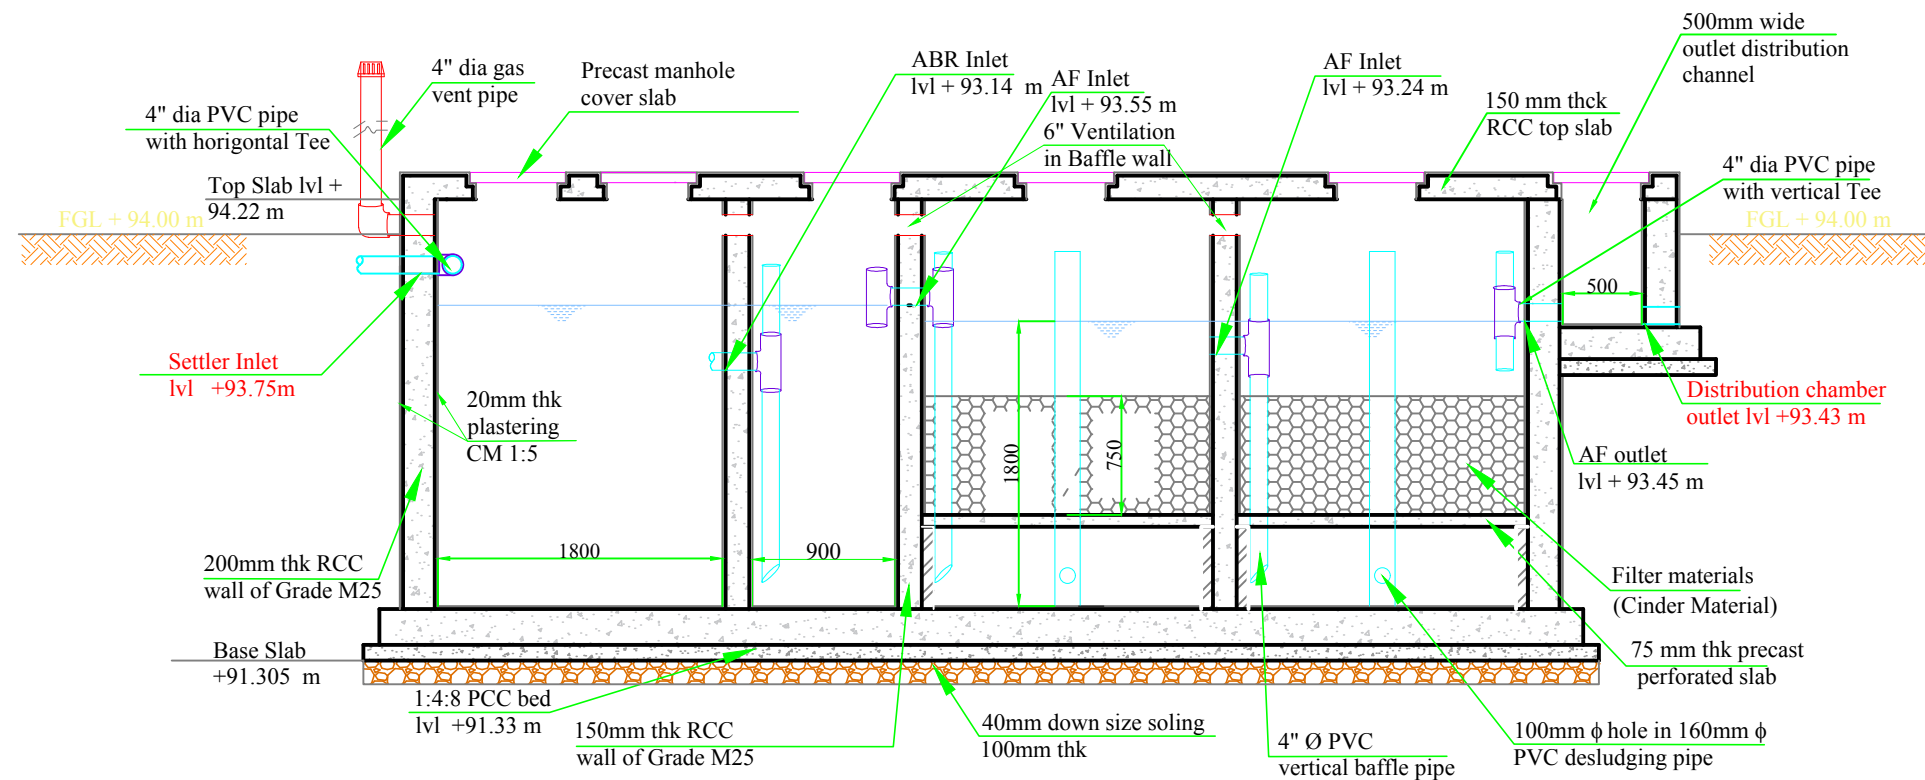

Cross section @ A-A

DRAWING TITLE:
Faecal Sludge Treatment Plant, Khandela, Rajasthan

PROJECT:
Capacity Building Support for Innovative Sanitation Solution for Rajasthan

DRAWING NO.:
BMGF/Khandela/D-ISAF-6

SCALE: NTS

NOTE:
This drawing is indicative and for bidding purpose only

CLIENTS:
Rajasthan Urban Infrastructure Development Project



CONSULTANT:
IPE Global Limited




IPE Global House
B-84, Defence Colony,
New Delhi - 110 024
Tel. +91 11 4075 5900
Email: ipe@ipeglobal.com
www.ipeglobal.com


SUB CONSULTANT:
CDD Society




Survey No.205 ,Opp.
Beedi Workers Colony,
Kommaghatta Road,
Bandemath, Kengeri
Satellite Town,
Bengaluru, Karnataka
560060

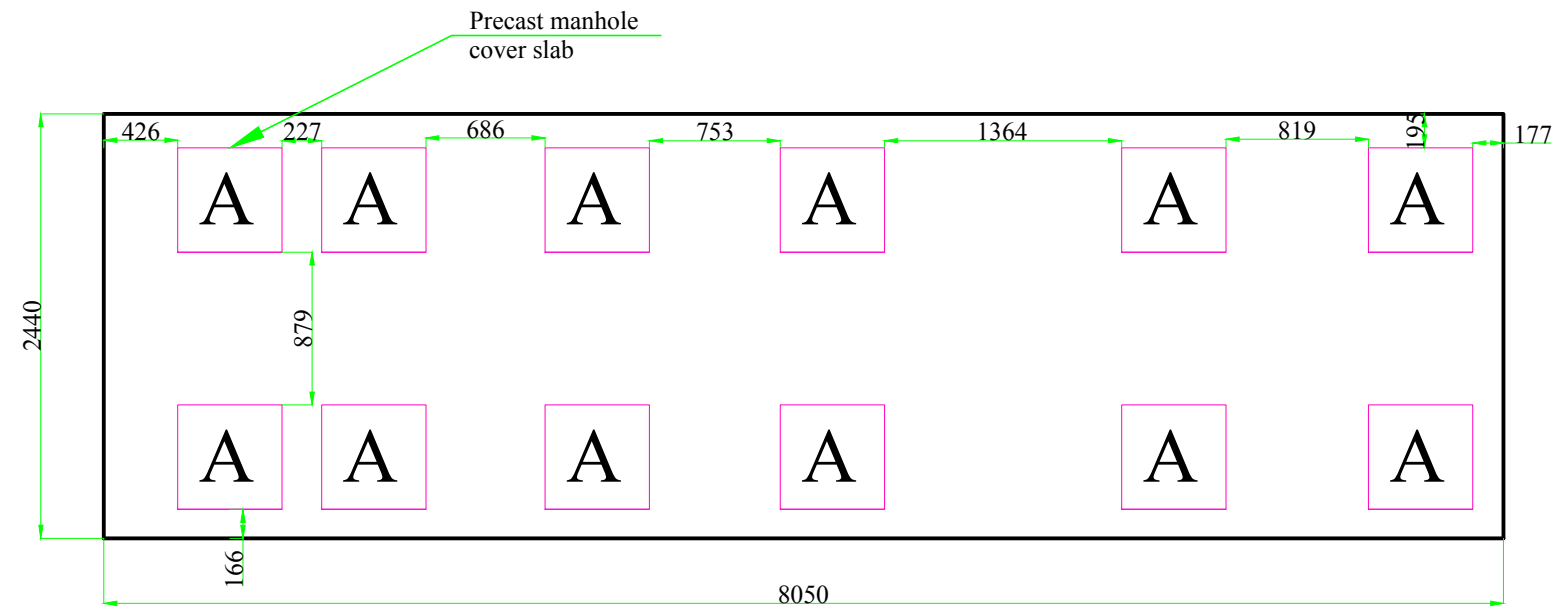

Plan of Manhole

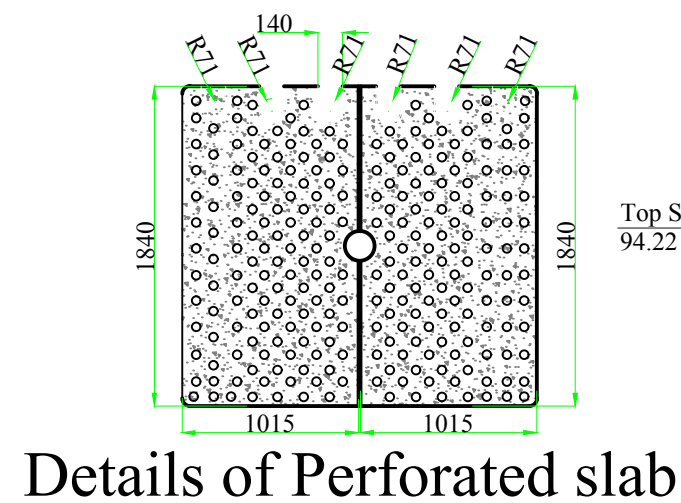

Details of Perforated slab

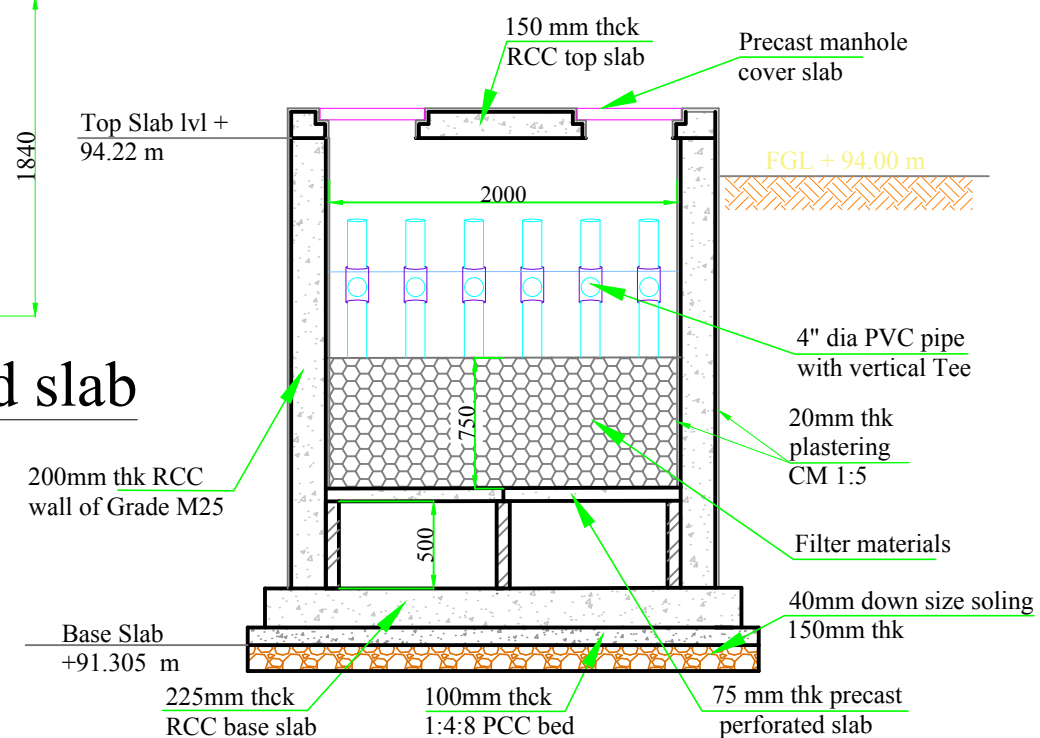

Cross section @ B-B

DRAWING TITLE:
Faecal Sludge Treatment Plant, Khandela, Rajasthan

DRAWING NO.:
BMGF/Khandela/D-ISAF-7

PROJECT:
Capacity Building Support for Innovative Sanitation Solution for Rajasthan

SCALE: NTS

NOTE:
This drawing is indicative and for bidding purpose only

CLIENTS:
Rajasthan Urban Infrastructure Development Project
RUIDP

CONSULTANT:
IPE Global Limited
IPE GLOBAL
Expanding Horizons. Enriching Lives.

IPE Global House
B-84, Defence Colony,
New Delhi - 110 024
Tel. +91 11 4075 5900
Email: ipe@ipeglobal.com
www.ipeglobal.com

SUB CONSULTANT:
CDD Society
Survey No.205 ,Opp.
Beedi Workers Colony,
Kommaghatta Road,
Bandemath, Kengeri
Satellite Town,
Bengaluru, Karnataka
560060

The diagram illustrates the internal layout of the PGF structure. Key features include:

- Dimensions:** The structure is 8000 mm long and 2000 mm wide.
- PGF Inlet:** Located at the top left, with a level of +93.28 m.
- HPGF DC inlet:** Located at the bottom left, with a level of +93.38 m.
- 4" dia perforated sampling pipe with vent cowl:** A vertical pipe on the right side.
- 4" dia PVC pipe at PGF outlet:** Located at the top right, with a level of +92.615 m.
- Maintenance pipe:** Located at the bottom right, with a level of +93.235 m.
- 4" dia PVC Perforated pipe:** A vertical pipe on the right side.
- Removable cap for perforated pipe:** Located at the bottom right, with a level of +93.253 m.
- 200mm thk BBM wall:** The outer boundary wall.
- 20mm thk plastering CM 1:5:** The inner wall finish.
- Brick Column of size 400x400mm:** A vertical support column on the right side.

The diagram illustrates the cross-section of a PGF Inlet structure. Key components and labels include:


- 200mm thk RCC wall**: The main vertical structure on the left.
- 20mm thk plastering CM 1:5**: Plastering on the wall.
- Precast manhole cover slab**: The top cover of the inlet.
- PGF Inlet**: The main inlet pipe, labeled with **lvl +93.28 m**.
- HPGF DC inlet**: A side inlet, labeled with **lvl +93.38 m**.
- Base Slab**: The bottom foundation, labeled with **lvl + 92.44 m**.
- Brick bat filling**: Filling material between the wall and the base slab.
- 1:4:8 PCC bed**: The concrete bed under the base slab.
- Filter materials size 10 - 12 mm**: Filter material layer above the PCC bed.
- 4" dia perforated sampling pipe with vent cowl**: Sampling pipes for water quality monitoring.
- Filter materials size 90 - 120 mm**: Coarse filter material layer.
- M20 grade RCC base slab**: The main base slab.
- Filter materials size 16 - 20 mm**: Fine filter material layer.
- Precast manhole cover slab**: The top cover on the right side.
- Maintenance pipe**: A pipe for access, labeled with **lvl + 93.235 m**.
- 4" dia PVC pipe at PG outlet**: The outlet pipe, labeled with **lvl +92.615 m**.
- Liquid level control pipe (Pipe can be rotated)**: A pipe for monitoring liquid levels.
- FGL + 94.00 m**: Finished Ground Level.

Diagram illustrating the cross-section of a soakaway structure. Key components and dimensions are labeled:

- Top Level:** FGL + 94.00 m
- Maintenance pipe:** lvl + 95.825 m, diameter 2000
- Removable cap for perforated pipe:** lvl + 93.253 m
- Plastering:** 20mm thk plastering CM 1:5
- Structure Support:** 150mm Thk Stone-Soling
- Base Slab:** 100mm tk, composed of 1:2:4 Cement concrete base slab and 1:2:4 PCC bed
- Filter Materials:** size 16 - 20 mm
- Wall:** 200mm thk BBM wall

SUB CONSULTANT:
CDD Society

Survey No.205 ,Opp.
Beedi Workers Colony,
Kommaghatta Road,
Bandemath, Kengeri
Satellite Town,
Bengaluru, Karnataka
560060

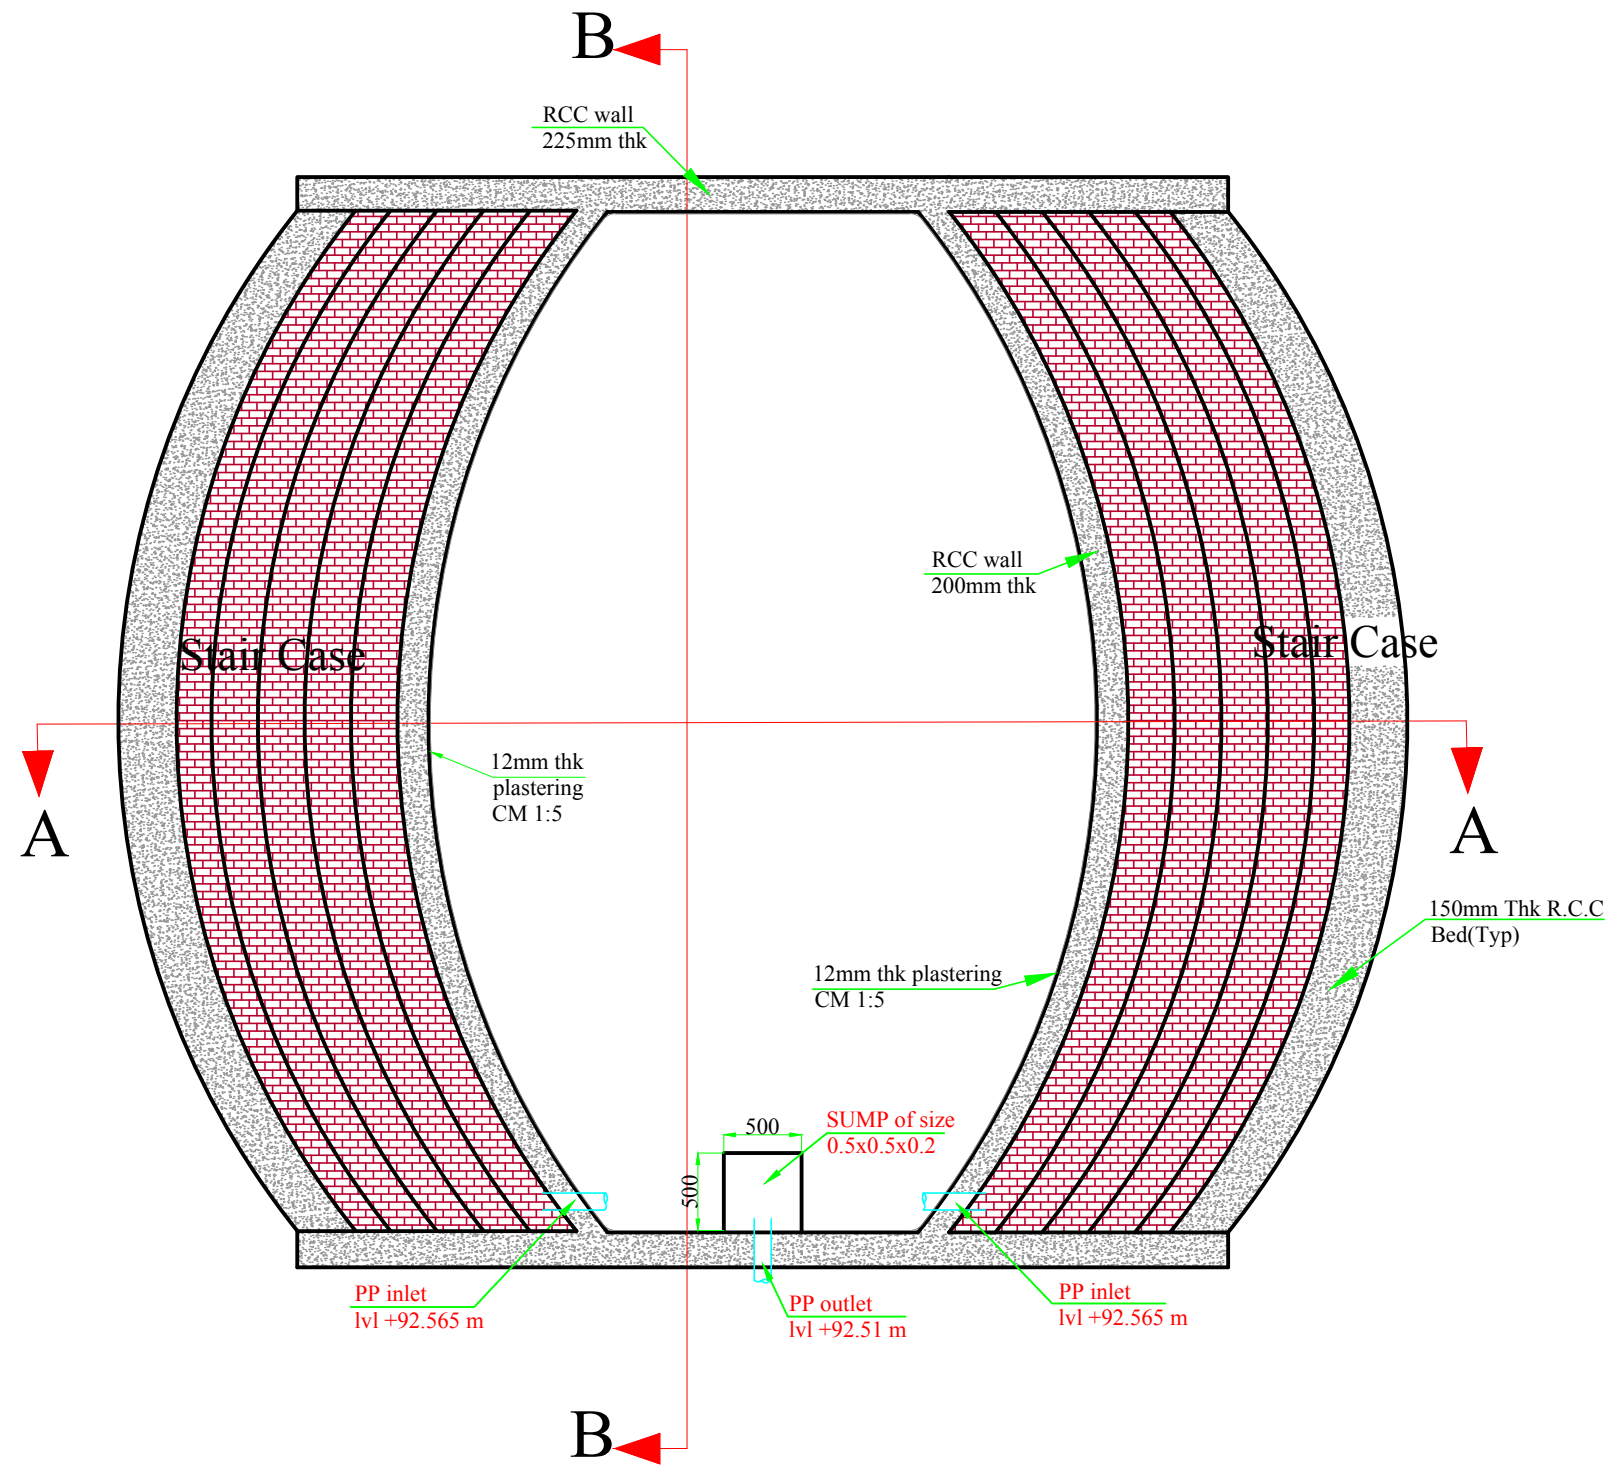

Plan of Polishing Pond

DRAWING TITLE:
Faecal Sludge Treatment Plant, Khandela, Rajasthan

DRAWING NO.:
BMGF/Khandela/D-PP-9

PROJECT:
Capacity Building Support for Innovative Sanitation Solution for Rajasthan

SCALE: NTS

NOTE:
This drawing is indicative and for bidding purpose only

CLIENTS:
Rajasthan Urban Infrastructure Development
Project



CONSULTANT:
**IPE Global
Limited**




IPE Global House
B-84, Defence Colony,
New Delhi - 110 024
Tel. +91 11 4075 5900
Email: ipe@ipeglobal.com
www.ipeglobal.com


SUB CONSULTANT:
CDD Society



Survey No.205 ,Opp.
Beedi Workers Colony,
Kommaghatta Road,
Bandemath, Kengeri
Satellite Town,
Bengaluru, Karnataka
560060

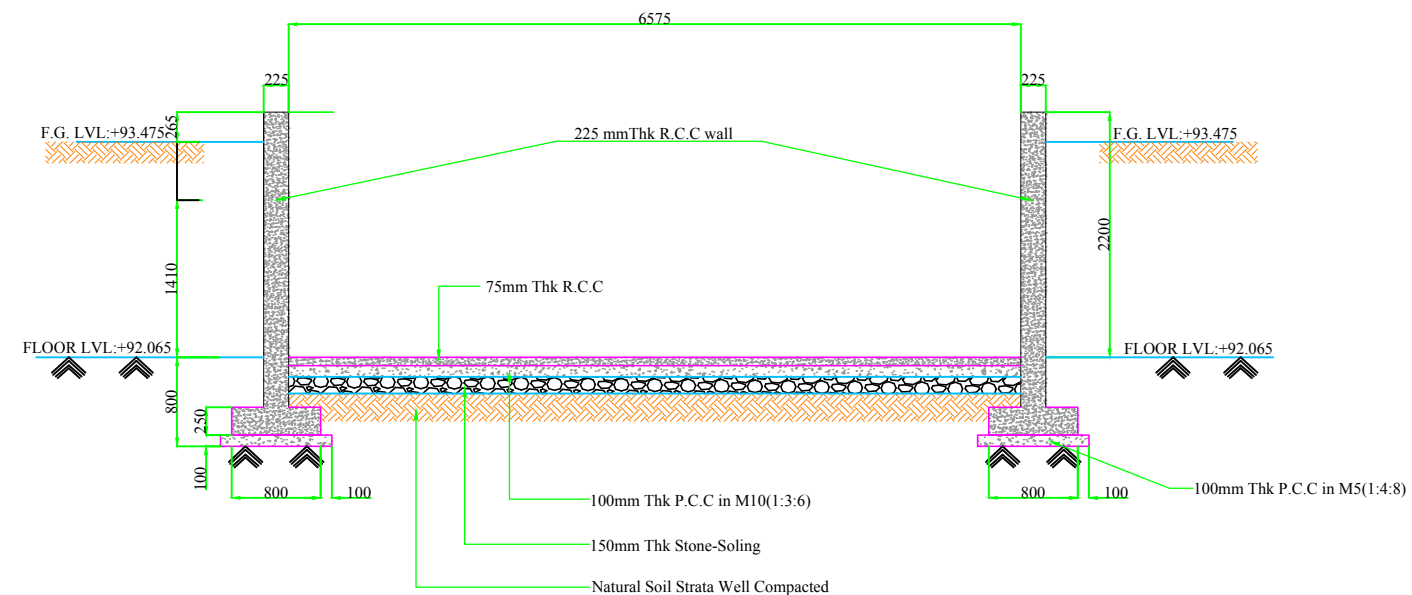

Cross Section of B-B

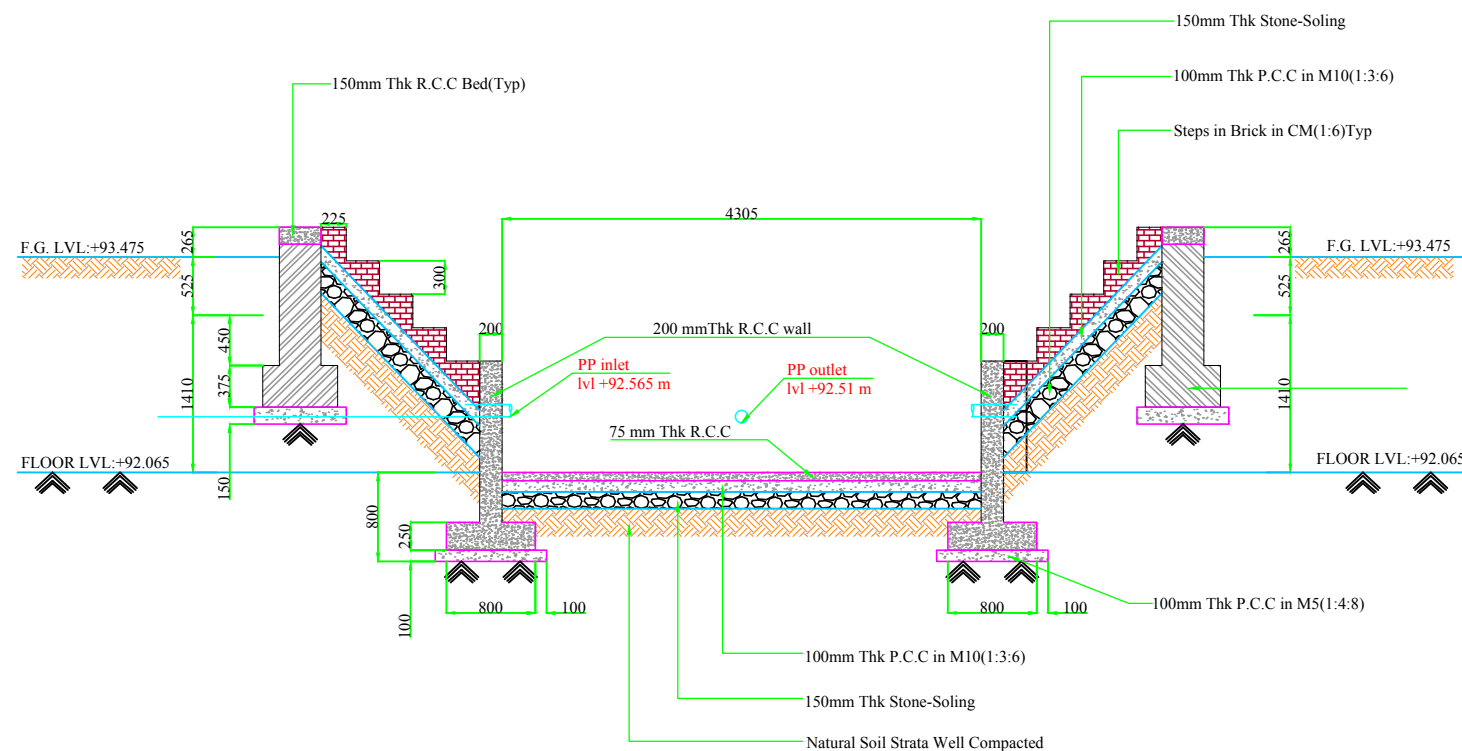

Cross Section of A-A

DRAWING TITLE:

Faecal Sludge Treatment Plant, Khandela, Rajasthan

DRAWING NO.:

BMGF/Khandela/D-PP-10

NOTE:

This drawing is indicative and for bidding purpose only

SCALE: NTS

PROJECT:

Capacity Building Support for Innovative Sanitation Solution for Rajasthan

CLIENTS:

Rajasthan Urban Infrastructure Development
Project



CONSULTANT:	
-------------	--

CONSULTANT:
I P E G l o b a l
L i m i t e d

IPE GLOBAL
Expanding Horizons. Enriching Lives.

IPE Global House
B-84, Defence Colony,
New Delhi - 110 024
Tel. +91 11 4075 5900
Email: ipe@ipeglobal.com
www.ipeglobal.com


SUB CONSULTANT:

SUB CONSULTANT:
CDD Society




Survey No.205 ,Opp.
Beedi Workers Colony,
Kommaghatta Road,
Bandemath, Kengeri
Satellite Town,
Bengaluru, Karnataka
560060

OPERATOR ROOM

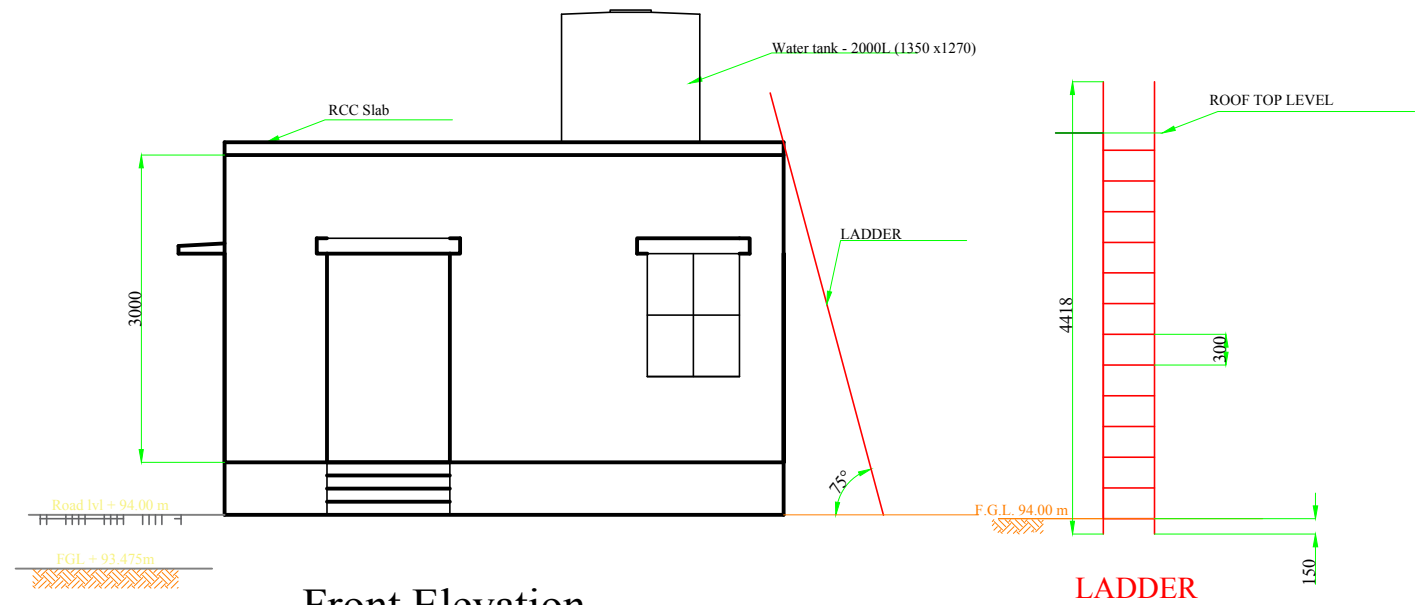


Front Elevation

D- Door - 1200 X 2100
D1- Bathroom door - 800 X 1900
W- Window - 900 X 1200
V- Ventilator- 600 X 400
(500 mm below bottom of the roof)

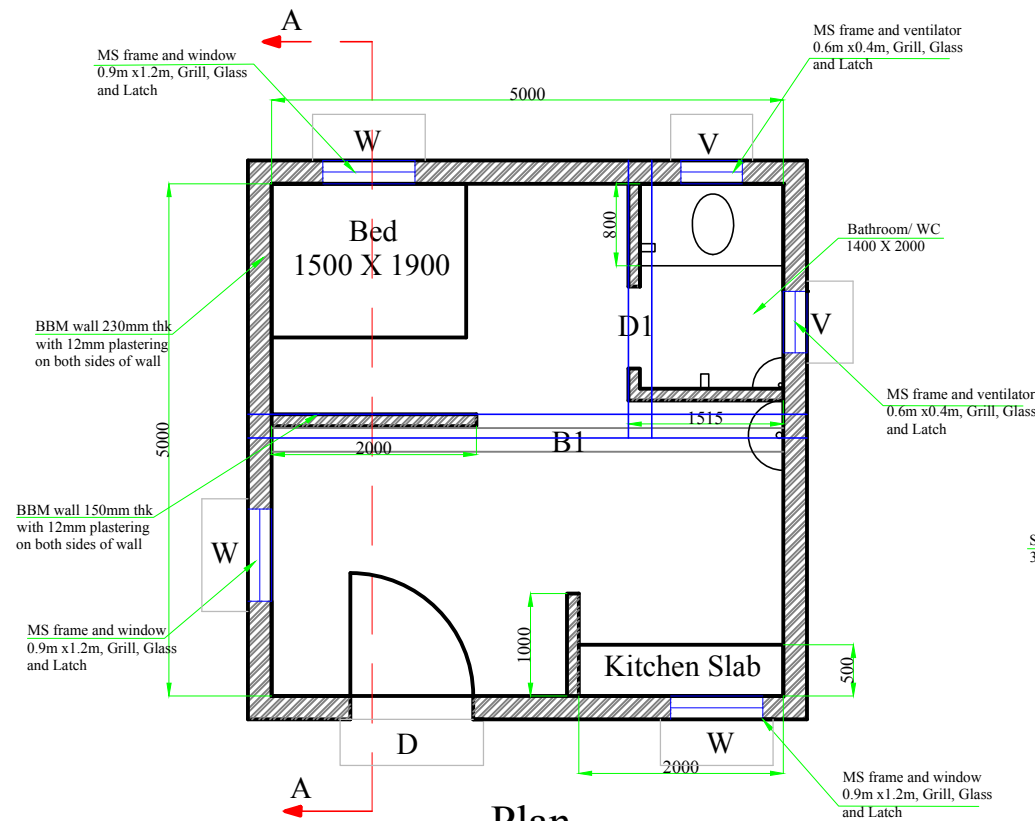

Plan

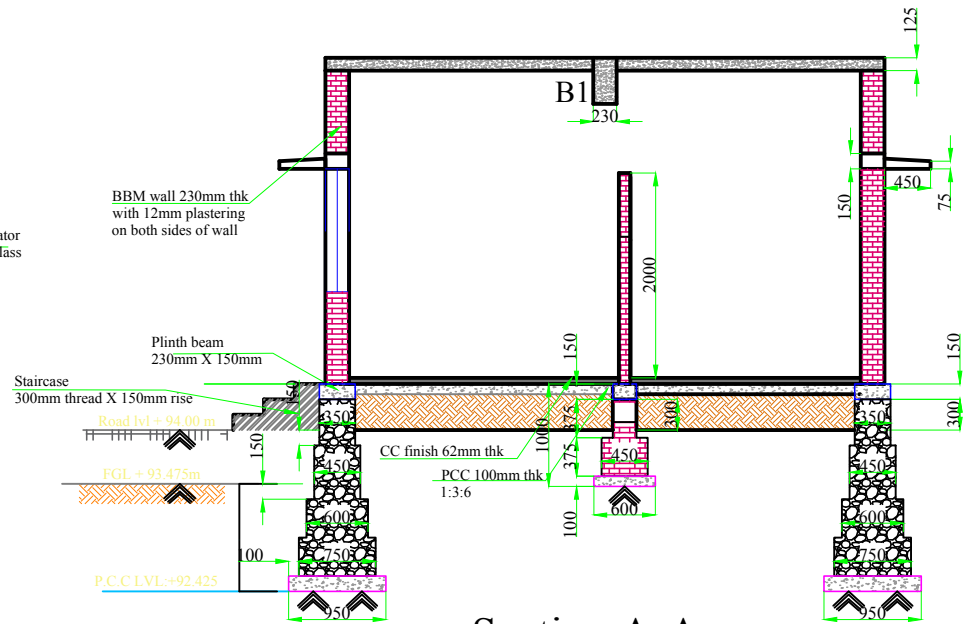

Section A-A

DRAWING TITLE:
Faecal Sludge Treatment Plant, Khandela, Rajasthan

PROJECT:
Capacity Building Support for Innovative Sanitation Solution for Rajasthan

DRAWING NO.:
BMGF/Khandela/D-OR-11

SCALE: NTS

NOTE:
This drawing is indicative and for bidding purpose only

CLIENTS:
Rajasthan Urban Infrastructure Development Project

RUIDP

CONSULTANT:
IPE Global Limited

IPE Global House
B-84, Defence Colony,
New Delhi - 110 024
Tel. +91 11 4075 5900
Email: ipe@ipeglobal.com
www.ipeglobal.com


Expanding Horizons. Enriching Lives.

SUB CONSULTANT:
CDD Society

Survey No.205 ,Opp.
Beedi Workers Colony,
Kommaghatta Road,
Bandemath, Kengeri
Satellite Town,
Bengaluru, Karnataka
560060


Consortium for DEWATS Dissemination Society

GUARD ROOM

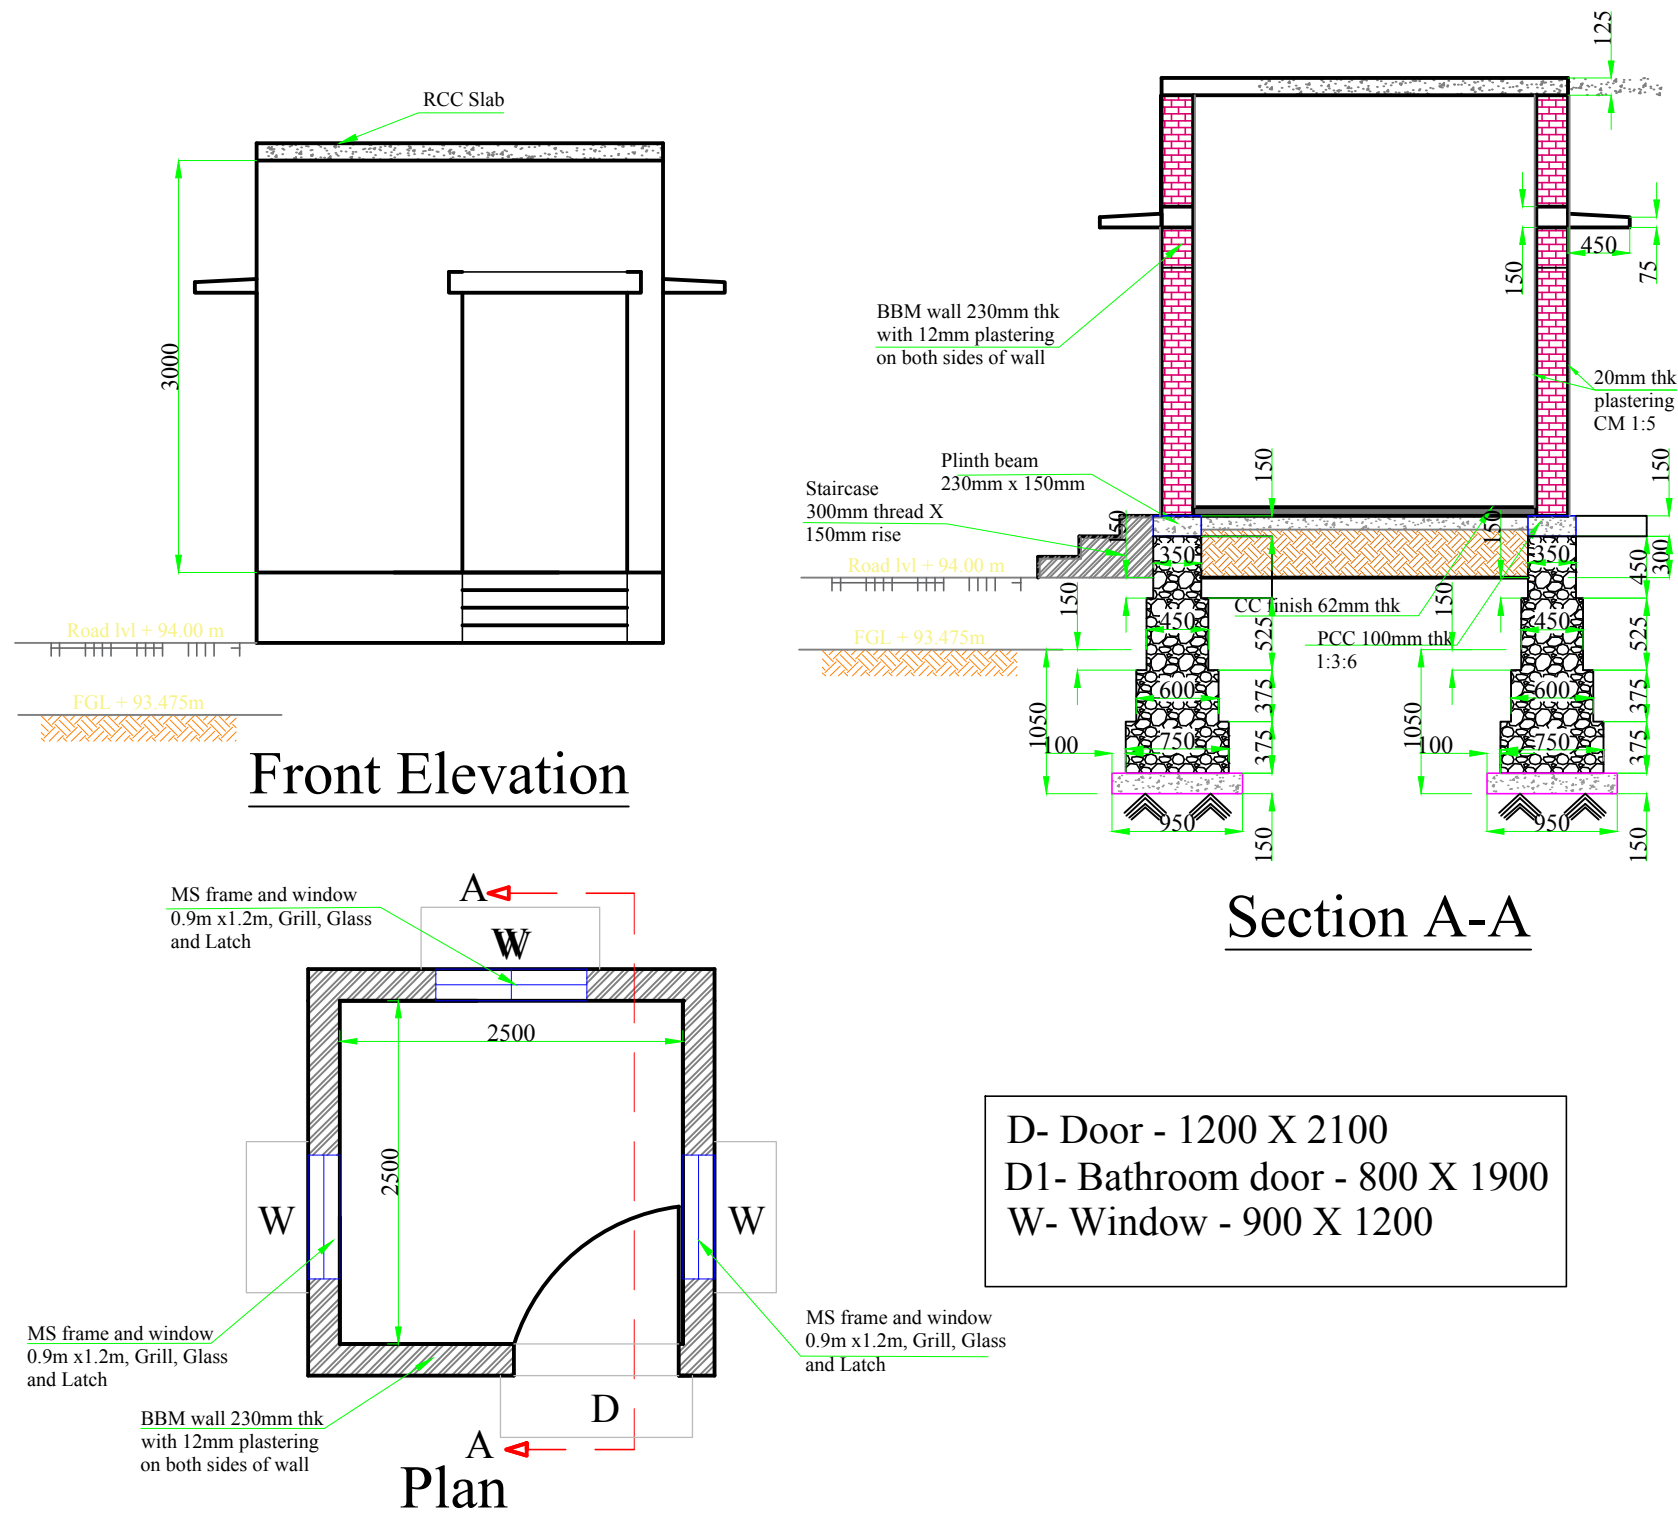

DRAWING TITLE: Faecal Sludge Treatment Plant, Khandela, Rajasthan	DRAWING NO.: BMGF/Khandela/D-GR-12	NOTE: This drawing is indicative and for bidding purpose only	CLIENTS: Rajasthan Urban Infrastructure Development Project 	CONSULTANT: IPE Global Limited  IPE Global House B-84, Defence Colony, New Delhi - 110 024 Tel. +91 11 4075 5900 Email: ipe@ipeglobal.com www.ipeglobal.com Expanding Horizons. Enriching Lives.	SUB CONSULTANT: CDD Society  Consortium for DEWATS Dissemination Society Survey No.205 ,Opp. Beedi Workers Colony, Kommaghatta Road, Bandemath, Kengeri Satellite Town, Bengaluru, Karnataka 560060
PROJECT: Capacity Building Support for Innovative Sanitation Solution for Rajasthan	SCALE: NTS				

SLUDGE STORAGE YARD

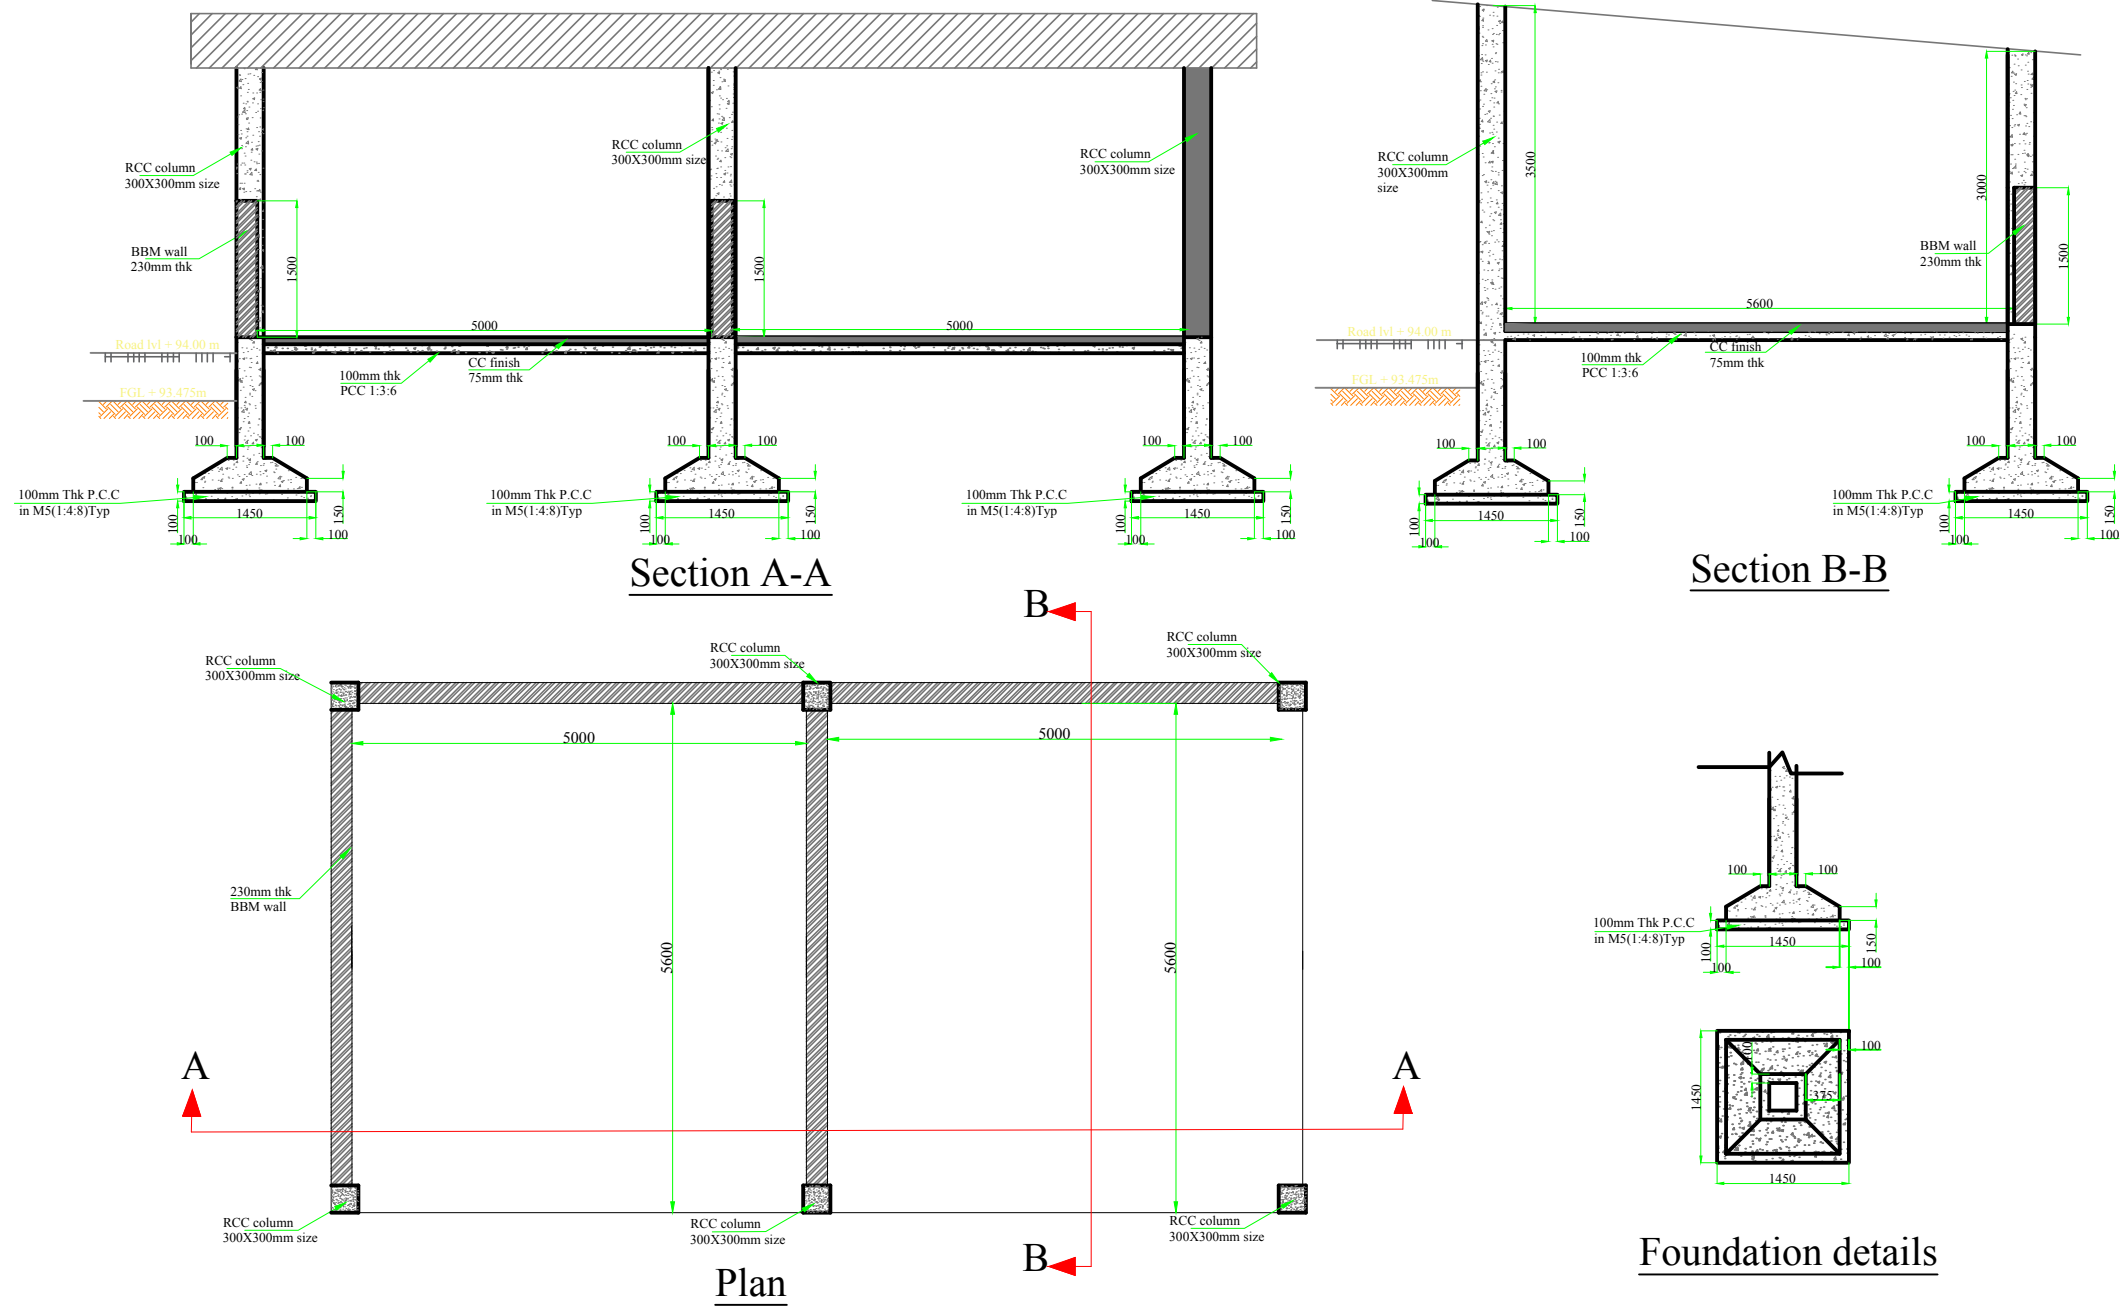

DRAWING TITLE:
Faecal Sludge Treatment Plant, Khandela, Rajasthan

PROJECT:
Capacity Building Support for Innovative Sanitation Solution for Rajasthan

DRAWING NO.:
BMGF/Khandela/D-SSY-13

SCALE: NTS

NOTE:
This drawing is indicative and for bidding purpose only



CLIENTS:
Rajasthan Urban Infrastructure Development
Project
RUIDP

CONSULTANT:
IPE Global Limited
IPE GLOBAL
Expanding Horizons. Enriching Lives.

IPE Global House
B-84, Defence Colony,
New Delhi - 110 024
Tel. +91 11 4075 5900
Email: ipe@ipeglobal.com
www.ipeglobal.com

SUB CONSULTANT:
CDD Society
Survey No.205 ,Opp.
Beedi Workers Colony,
Kommaghatta Road,
Bandemath, Kengeri
Satellite Town,
Bengaluru, Karnataka
560060

ROAD SECTION

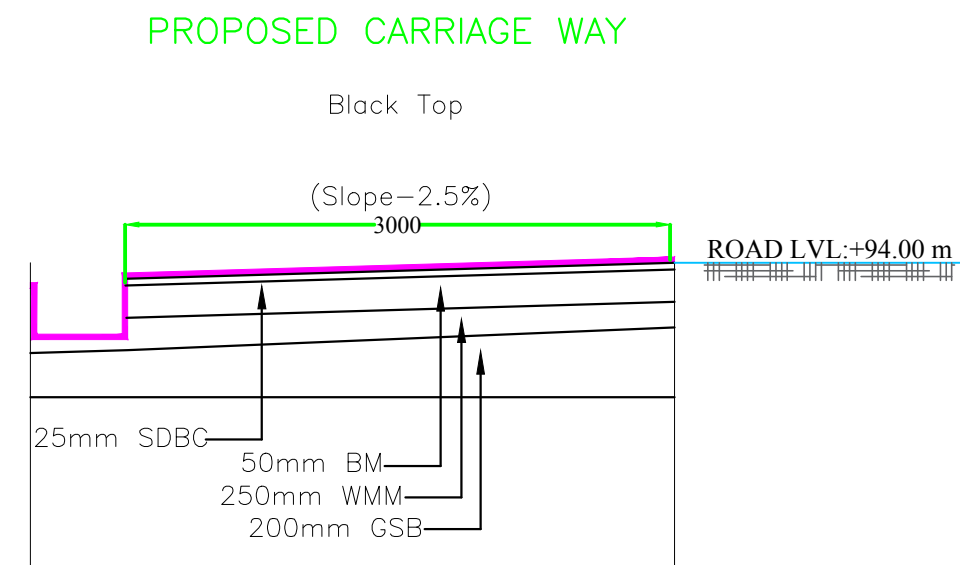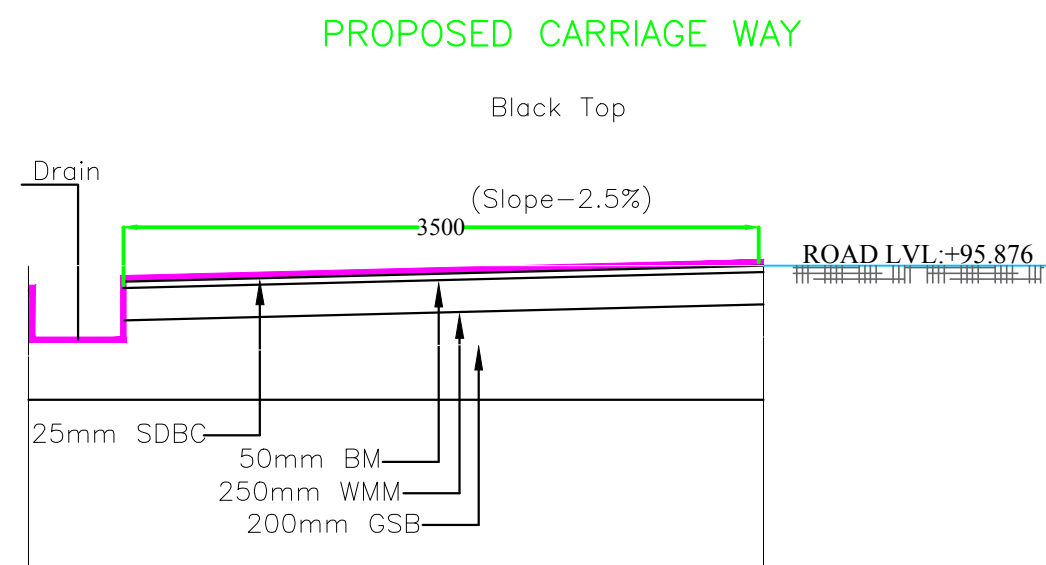

TYPICAL CROSS SECTION OF BLACKTOP ROAD

SDBC :-Semi Dense Bituminous Concrete

BM :-Bituminous Macadam

WMM :-Wet Mix Macadam

GSB :-Granular sub-base

DRAWING TITLE:
Faecal Sludge Treatment Plant, Khandela, Rajasthan

DRAWING NO.:
BMGF/Khandela/D-ROAD-14

PROJECT:
Capacity Building Support for Innovative Sanitation Solution for Rajasthan

SCALE: NTS

NOTE:
This drawing is indicative and for bidding purpose only

CLIENTS:
Rajasthan Urban Infrastructure Development
Project



CONSULTANT:
IPE Global
Limited






IPE Global House
B-84, Defence Colony,
New Delhi - 110 024
Tel. +91 11 4075 5900
Email: ipe@ipeglobal.com
www.ipeglobal.com

SUB CONSULTANT:
CDD Society



Survey No.205 ,Opp.
Beedi Workers Colony,
Kommaghatta Road,
Bandemath, Kengeri
Satellite Town,
Bengaluru, Karnataka
560060

RAMP SECTION

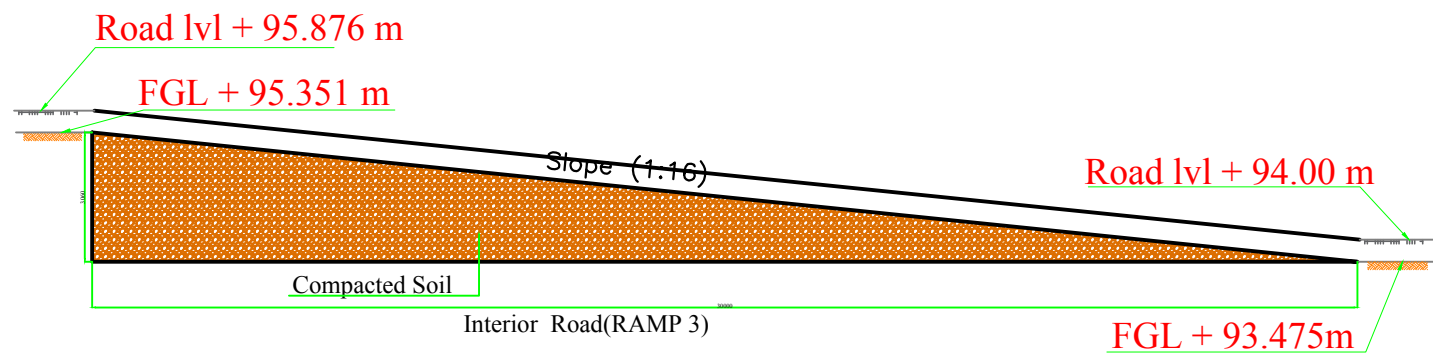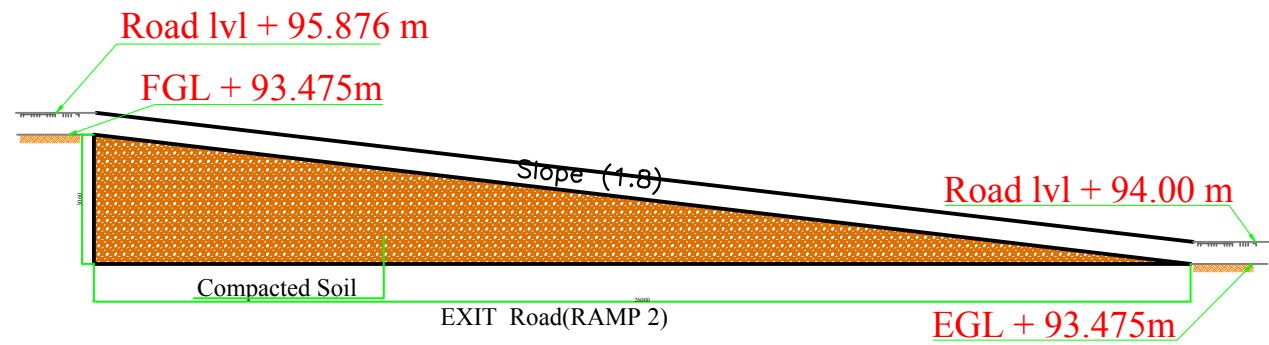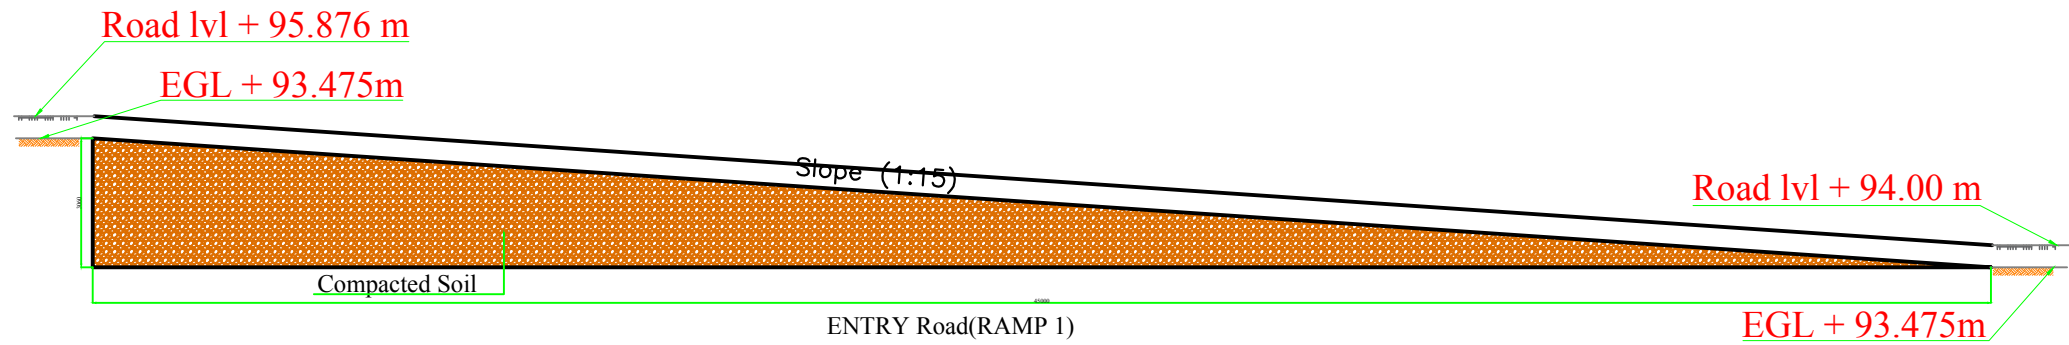

DRAWING TITLE:
Faecal Sludge Treatment Plant, Khandela, Rajasthan

PROJECT:
Capacity Building Support for Innovative Sanitation Solution for Rajasthan

DRAWING NO.:
BMGF/Khandela/D-RAMP-15

SCALE: NTS


NOTE:
This drawing is indicative and for bidding purpose only

CLIENTS:
Rajasthan Urban Infrastructure Development
Project
RUIDP

CONSULTANT:
IPE Global Limited
IPE Global House
B-84, Defence Colony,
New Delhi - 110 024
Tel. +91 11 4075 5900
Email: ipe@ipeglobal.com
www.ipeglobal.com

SUB CONSULTANT:
CDD Society
Survey No.205 ,Opp.
Beedi Workers Colony,
Kommaghatta Road,
Bandemath, Kengeri
Satellite Town,
Bengaluru, Karnataka
560060


STORM WATER DRAIN PLAN

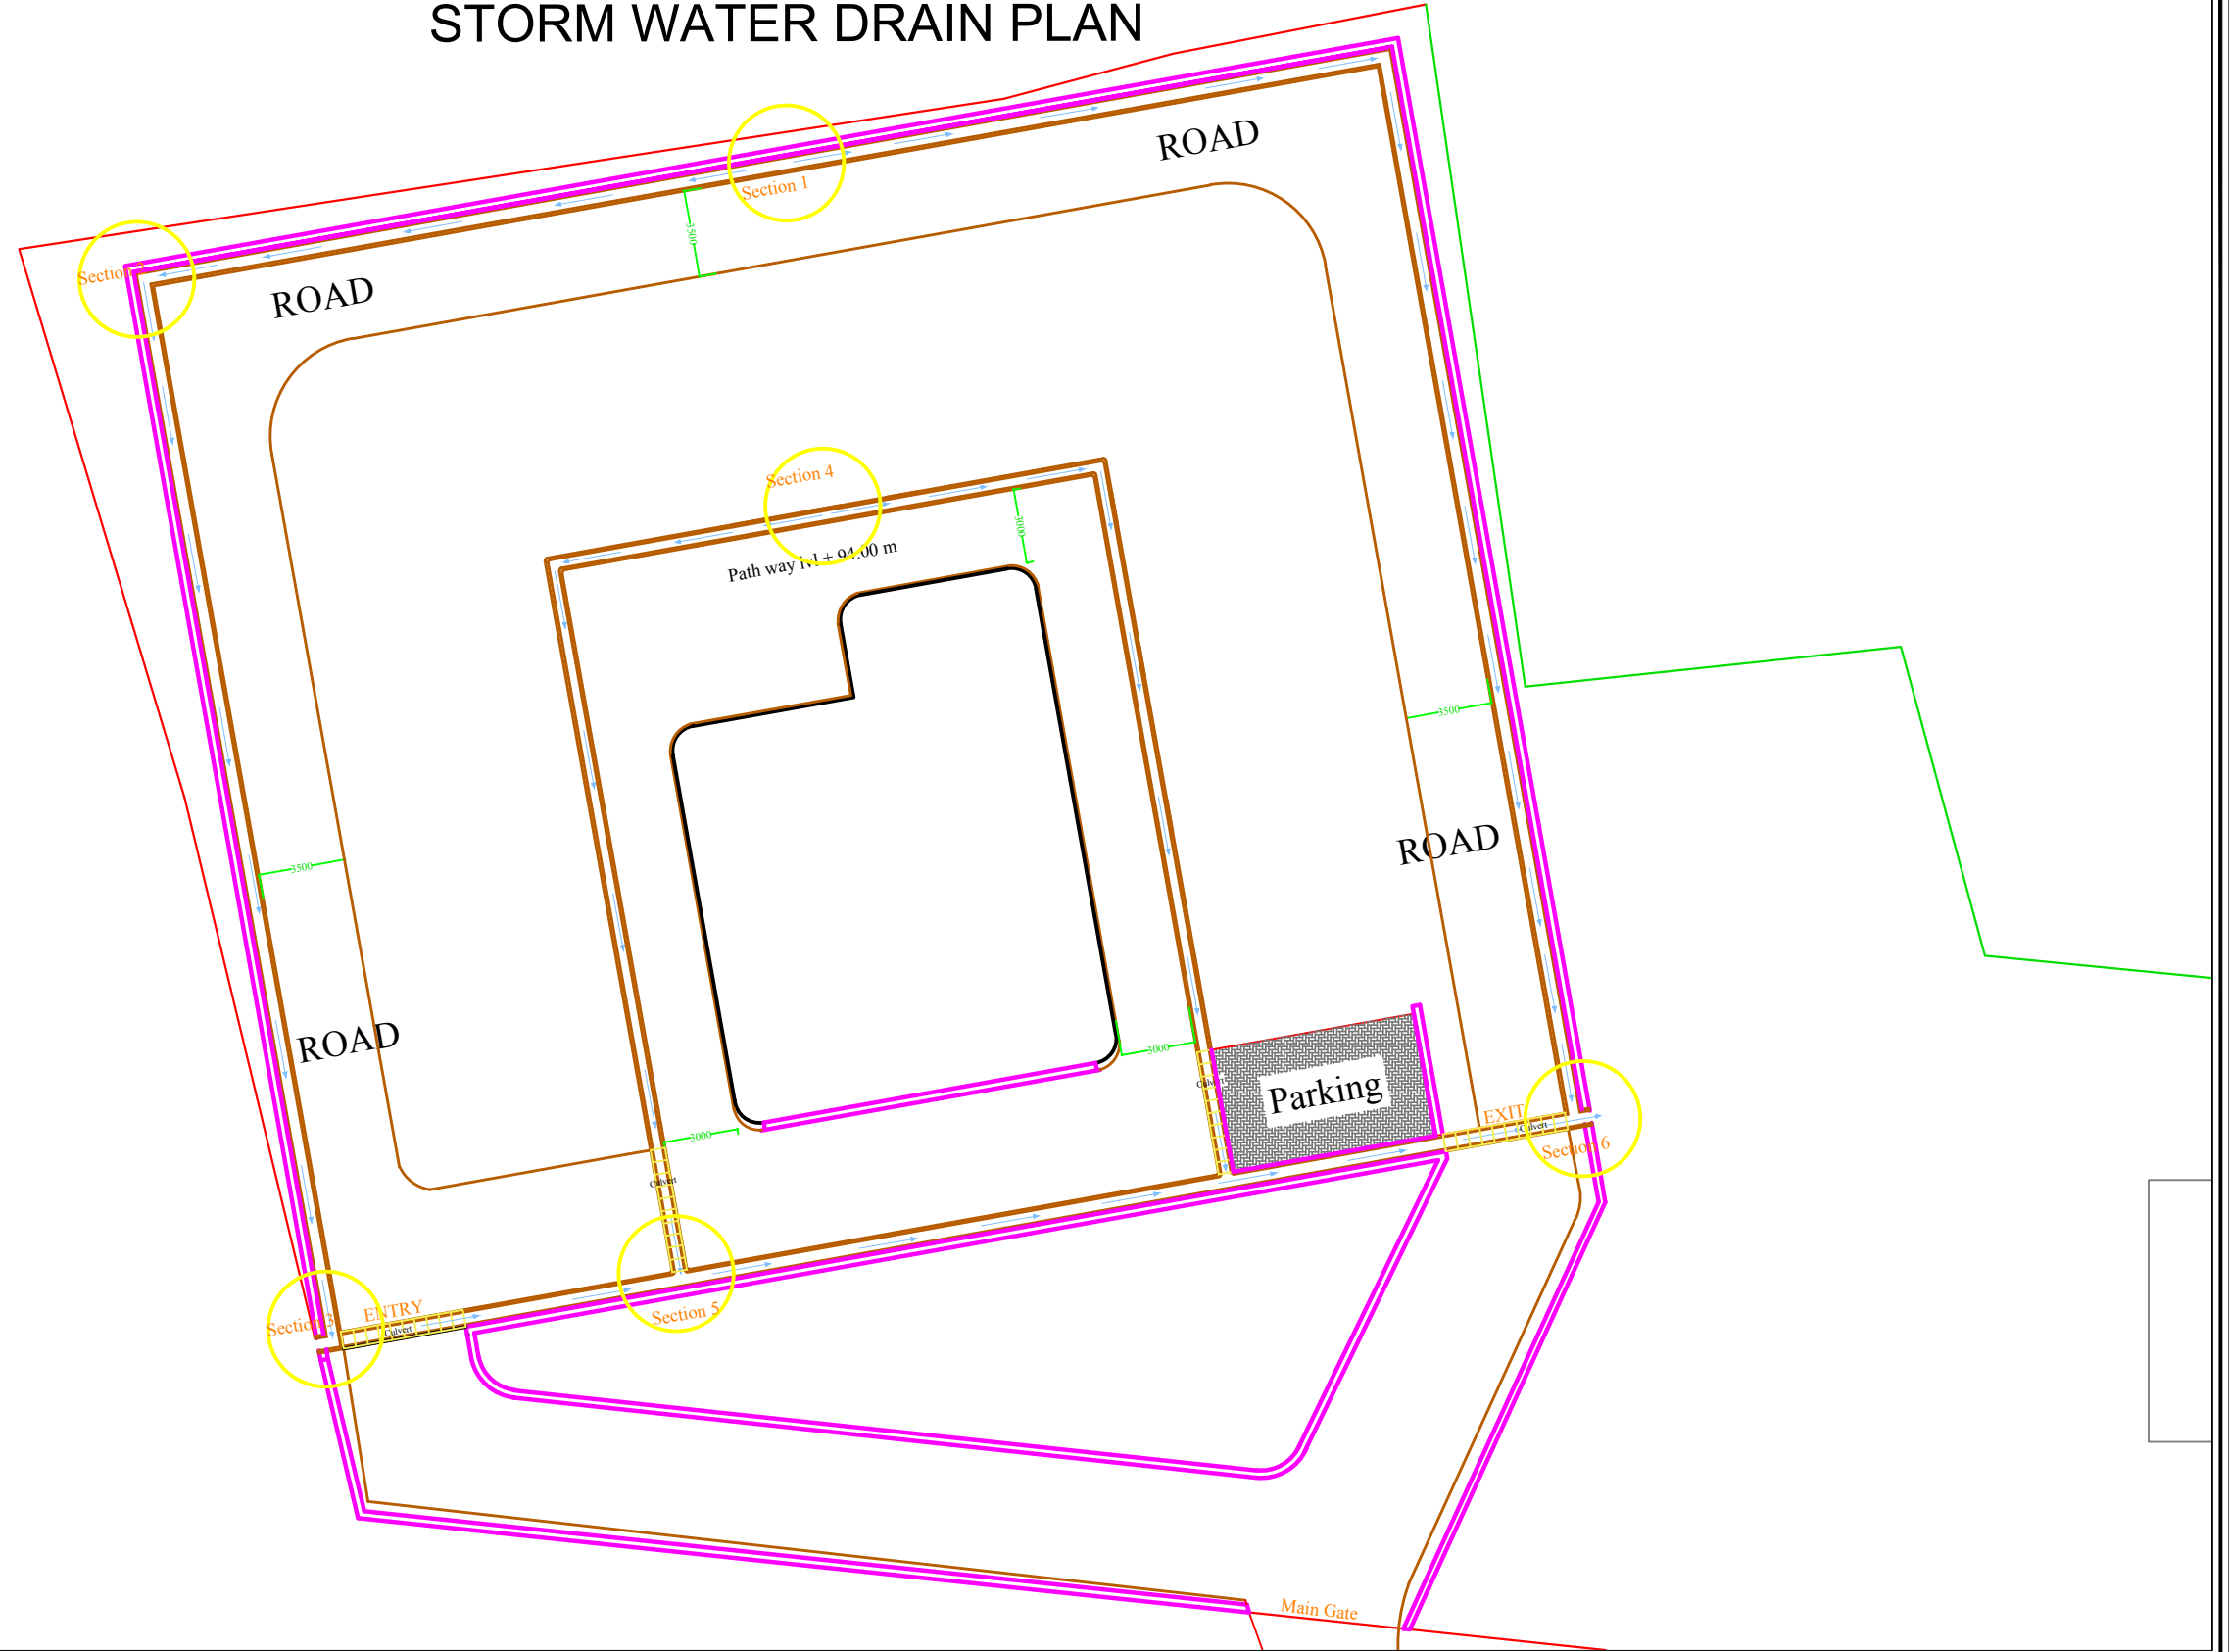

DRAWING TITLE: Faecal Sludge Treatment Plant, Khandela, Rajasthan	DRAWING NO.: BMGF/Khandela/D-SWD-16	NOTE: This drawing is indicative and for bidding purpose only	CLIENTS: Rajasthan Urban Infrastructure Development Project 	CONSULTANT: IPE Global Limited  IPE Global House B-84, Defence Colony, New Delhi - 110 024 Tel. +91 11 4075 5900 Email: ipe@ipeglobal.com www.ipeglobal.com	SUB CONSULTANT: CDD Society  Consortium for DEWATS Dissemination Society Survey No.205 ,Opp. Beedi Workers Colony, Kommaghatta Road, Bandemath, Kengeri Satellite Town, Bengaluru, Karnataka 560060
PROJECT: Capacity Building Support for Innovative Sanitation Solution for Rajasthan	SCALE: NTS				

Storm water drain

U-shaped drain

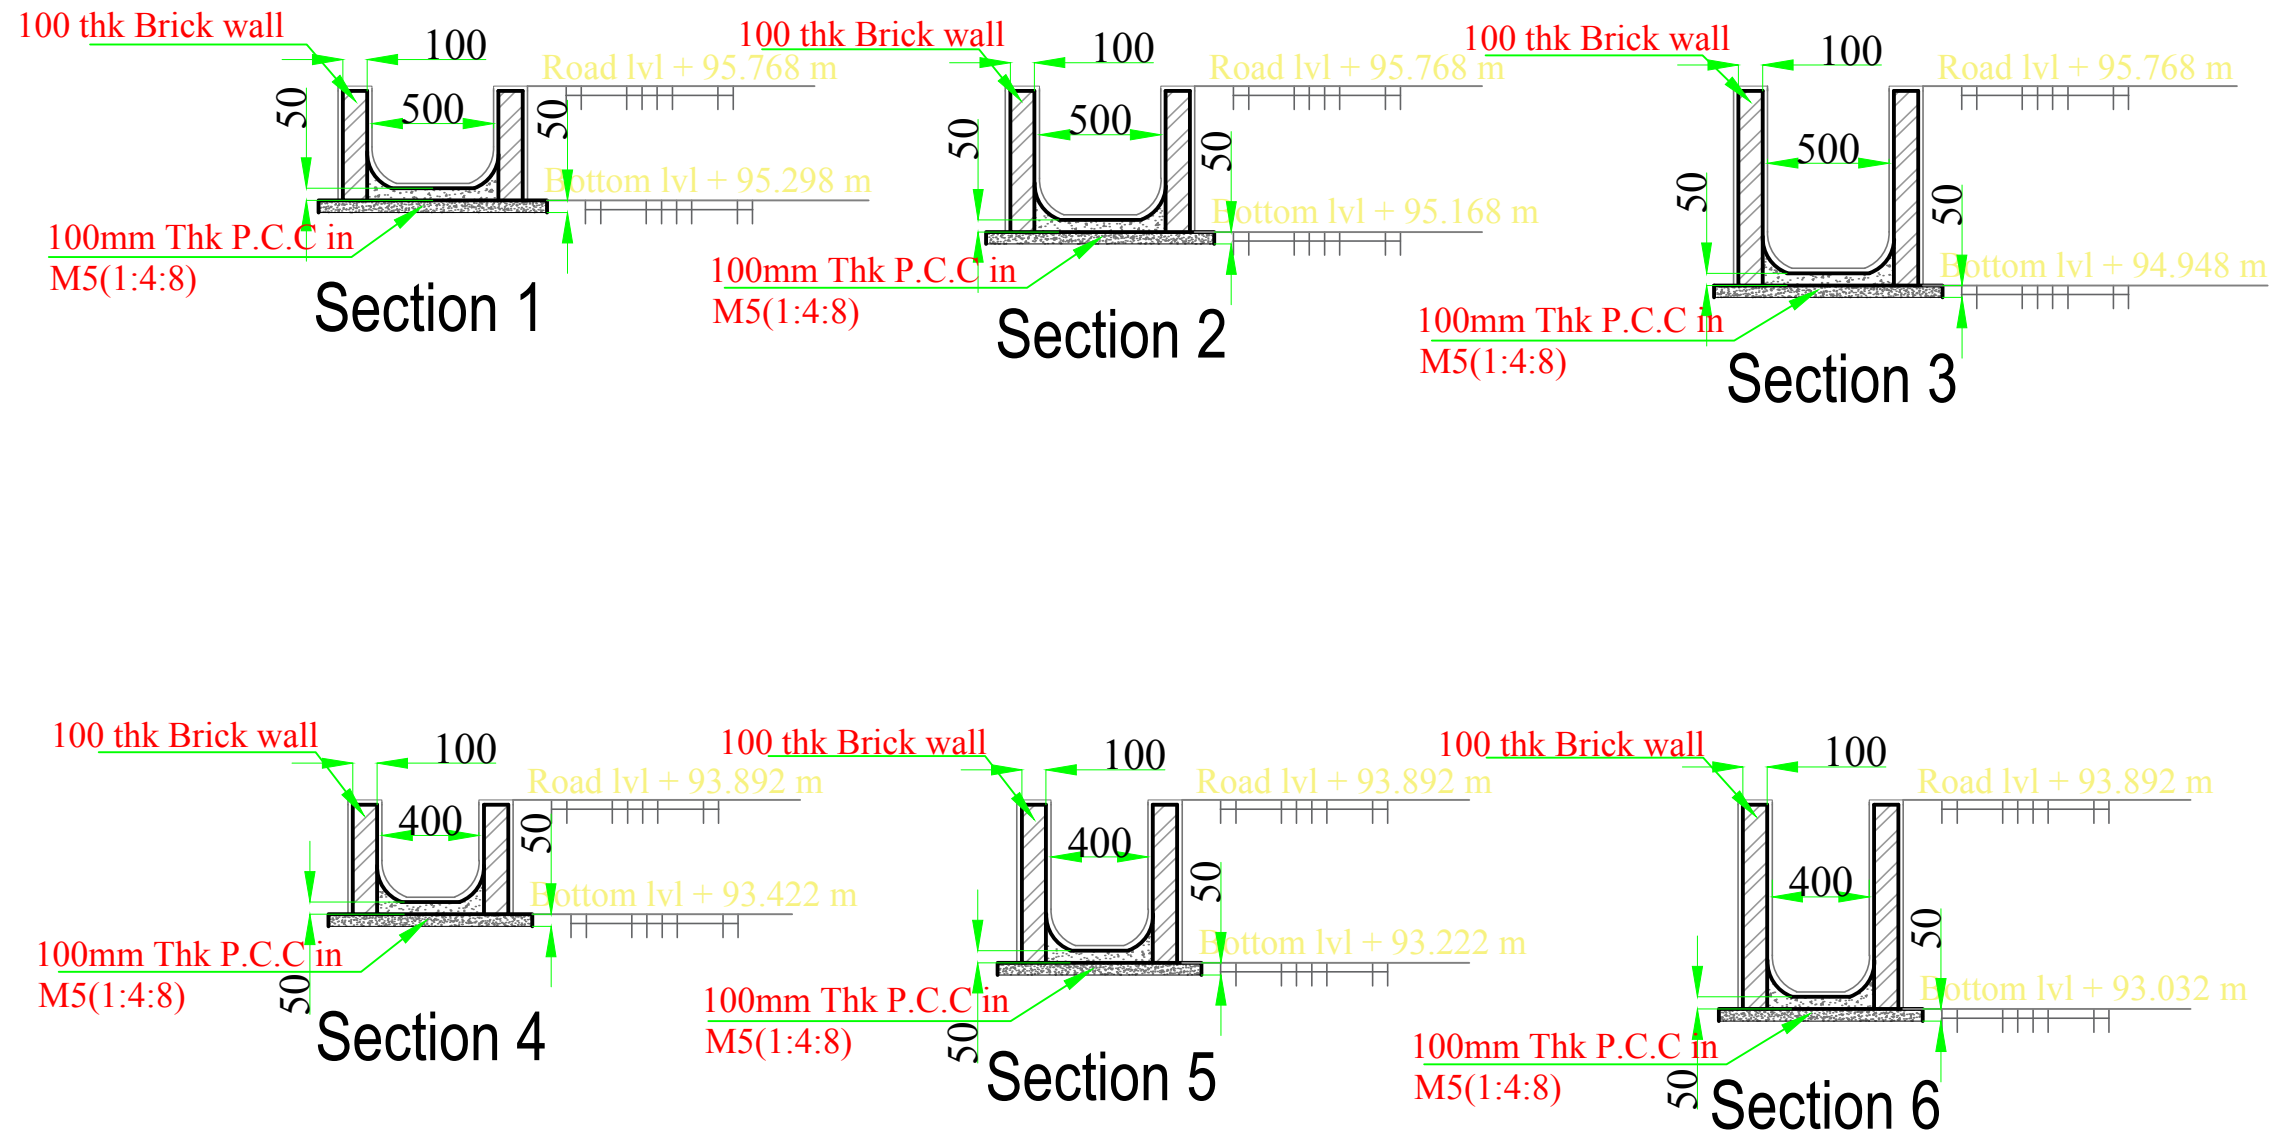

DRAWING TITLE:
Faecal Sludge Treatment Plant, Khandela, Rajasthan

DRAWING NO.:
BMGF/Khandela/D-SWD-17

PROJECT:
Capacity Building Support for Innovative Sanitation Solution for Rajasthan

SCALE: NTS

NOTE:
This drawing is indicative and for bidding purpose only

CLIENTS:
Rajasthan Urban Infrastructure Development Project



CONSULTANT:
IPE Global Limited




IPE Global House
B-84, Defence Colony,
New Delhi - 110 024
Tel. +91 11 4075 5900
Email: ipe@ipeglobal.com
www.ipeglobal.com

SUB CONSULTANT:
CDD Society



Survey No.205 ,Opp.
Beedi Workers Colony,
Kommaghatta Road,
Bandemath, Kengeri
Satellite Town,
Bengaluru, Karnataka
560060


RETAINING WALL

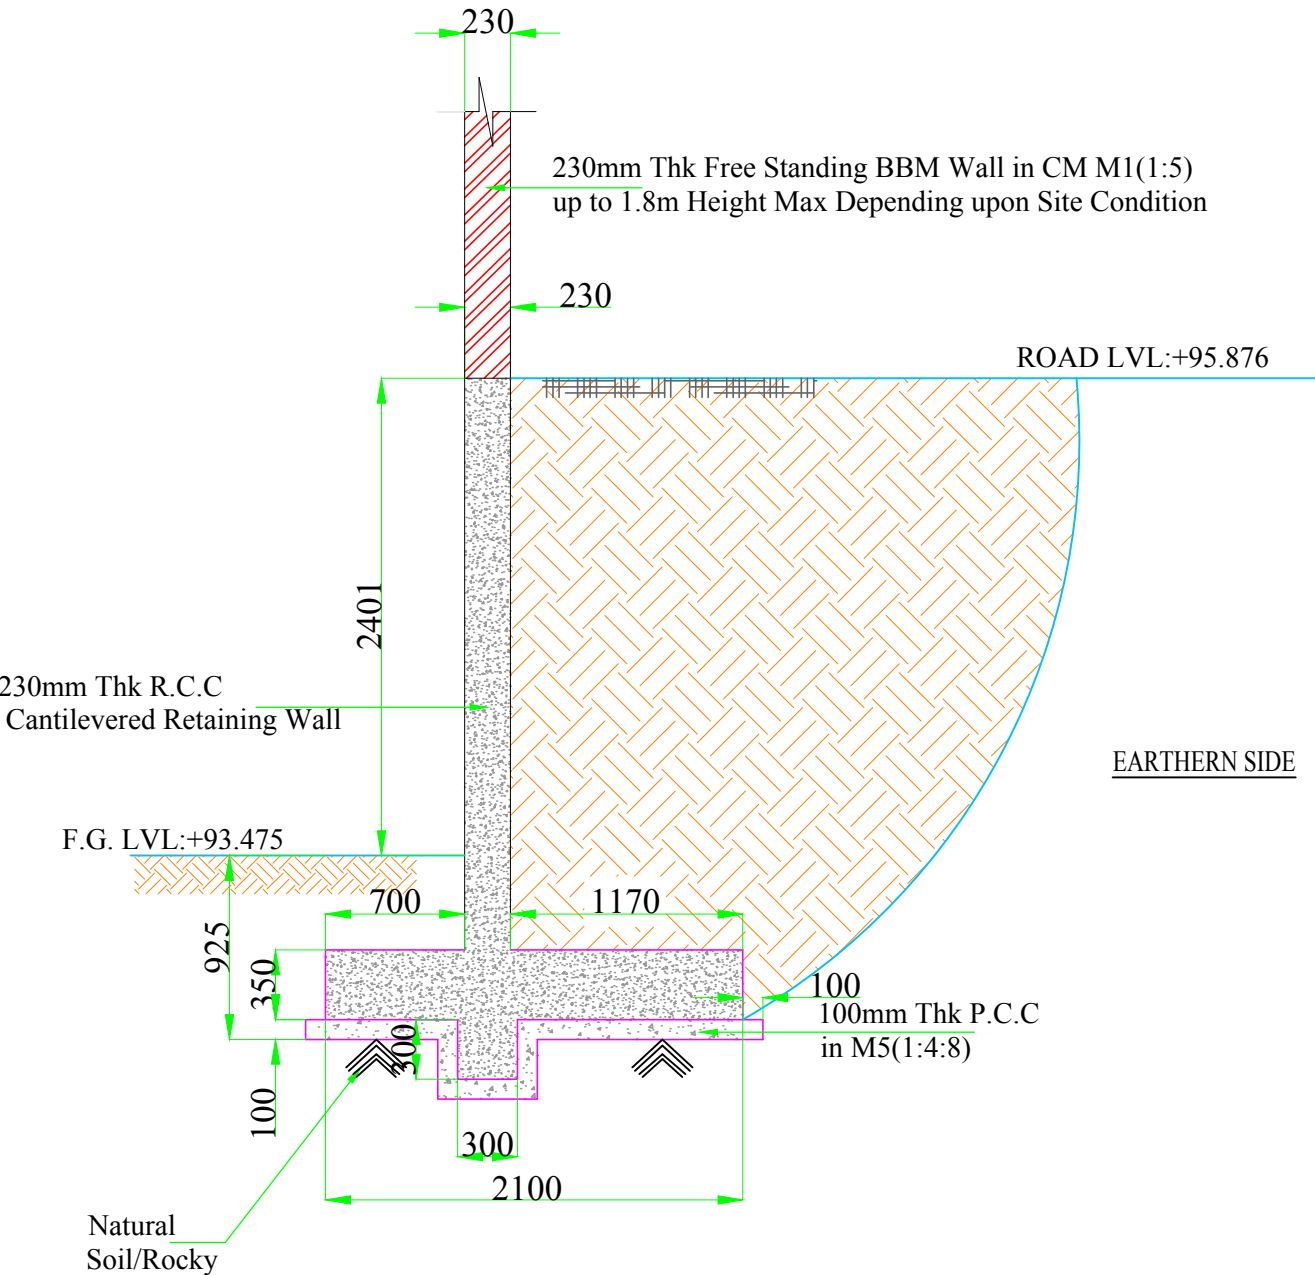


Section of Retaining Wall

DRAWING TITLE: Faecal Sludge Treatment Plant, Khandela, Rajasthan	DRAWING NO.: BMGF/Khandela/D-RW-18	NOTE: This drawing is indicative and for bidding purpose only	CLIENTS: Rajasthan Urban Infrastructure Development Project RUIDP	CONSULTANT: IPE Global Limited IPE Global House B-84, Defence Colony, New Delhi - 110 024 Tel. +91 11 4075 5900 Email: ipe@ipeglobal.com www.ipeglobal.com Expanding Horizons. Enriching Lives.	SUB CONSULTANT: CDD Society Survey No.205 ,Opp. Beedi Workers Colony, Kommaghatta Road, Bandemath, Kengeri Satellite Town, Bengaluru, Karnataka 560060
PROJECT: Capacity Building Support for Innovative Sanitation Solution for Rajasthan	SCALE: NTS				

REGISTER

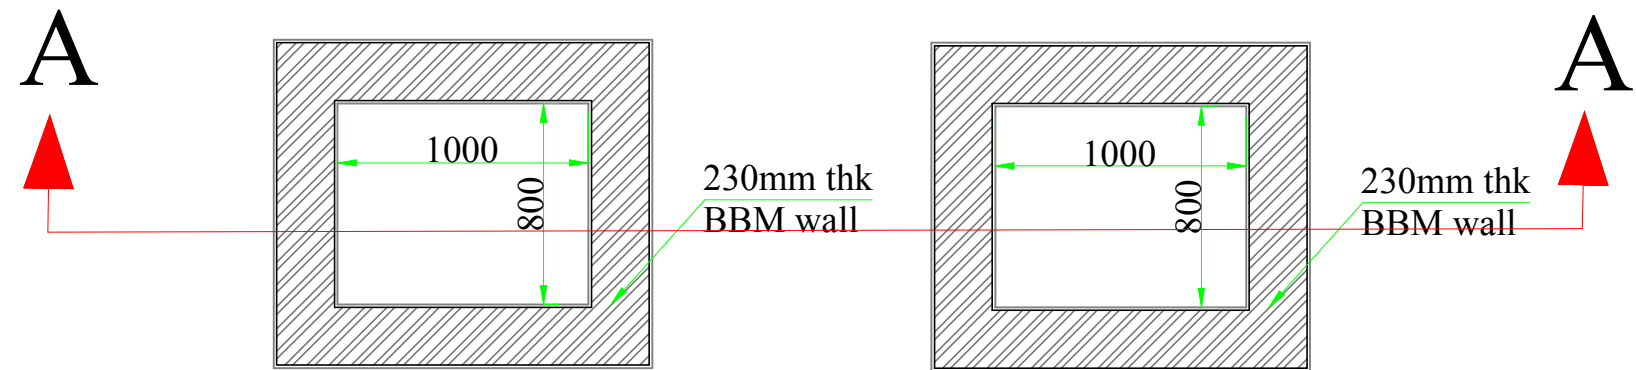

Plan of ISAF and PGF inlet Register

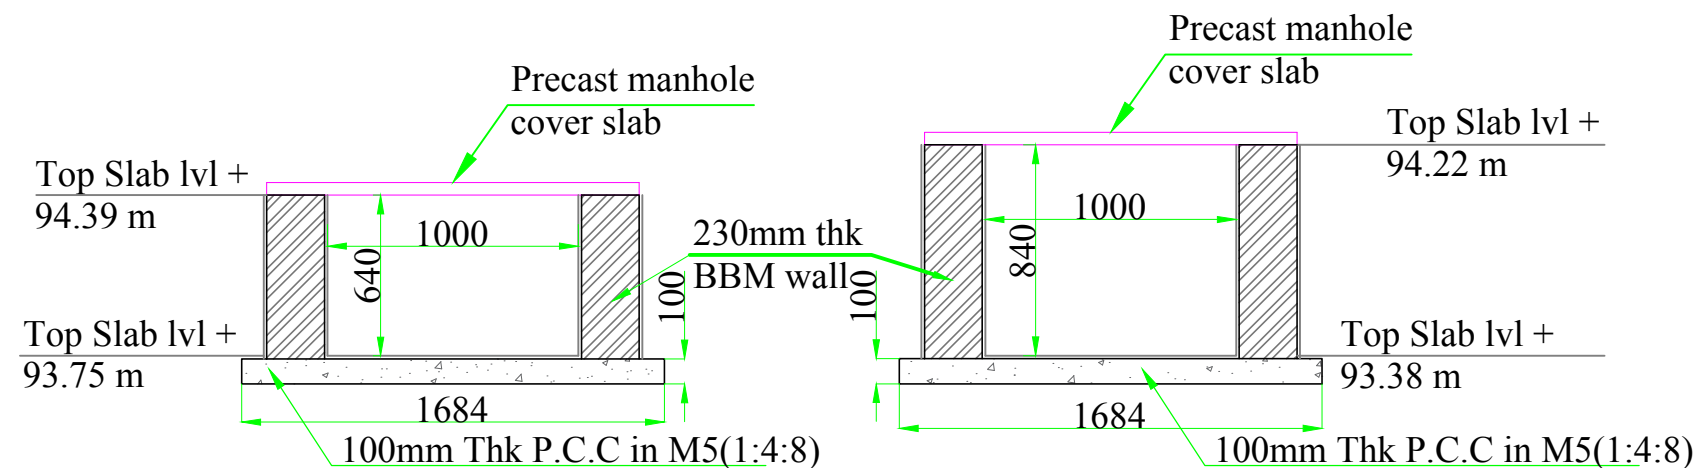

Section A-A for ISAF and PGF inlet Register

DRAWING TITLE:
Faecal Sludge Treatment Plant, Khandela, Rajasthan

DRAWING NO.:
BMGF/Khandela/D-REGISTER-19

PROJECT:
Capacity Building Support for Innovative Sanitation Solution for Rajasthan

SCALE: NTS

NOTE:
This drawing is indicative and for bidding purpose only

CLIENTS:
Rajasthan Urban Infrastructure Development
Project



CONSULTANT:
IPE Global
Limited




IPE Global House
B-84, Defence Colony,
New Delhi - 110 024
Tel. +91 11 4075 5900
Email: ipe@ipeglobal.com
www.ipeglobal.com

SUB CONSULTANT:
CDD Society



Survey No.205 ,Opp.
Beedi Workers Colony,
Kommaghatta Road,
Bandemath, Kengeri
Satellite Town,
Bengaluru, Karnataka
560060

SITE CONTOUR MAP

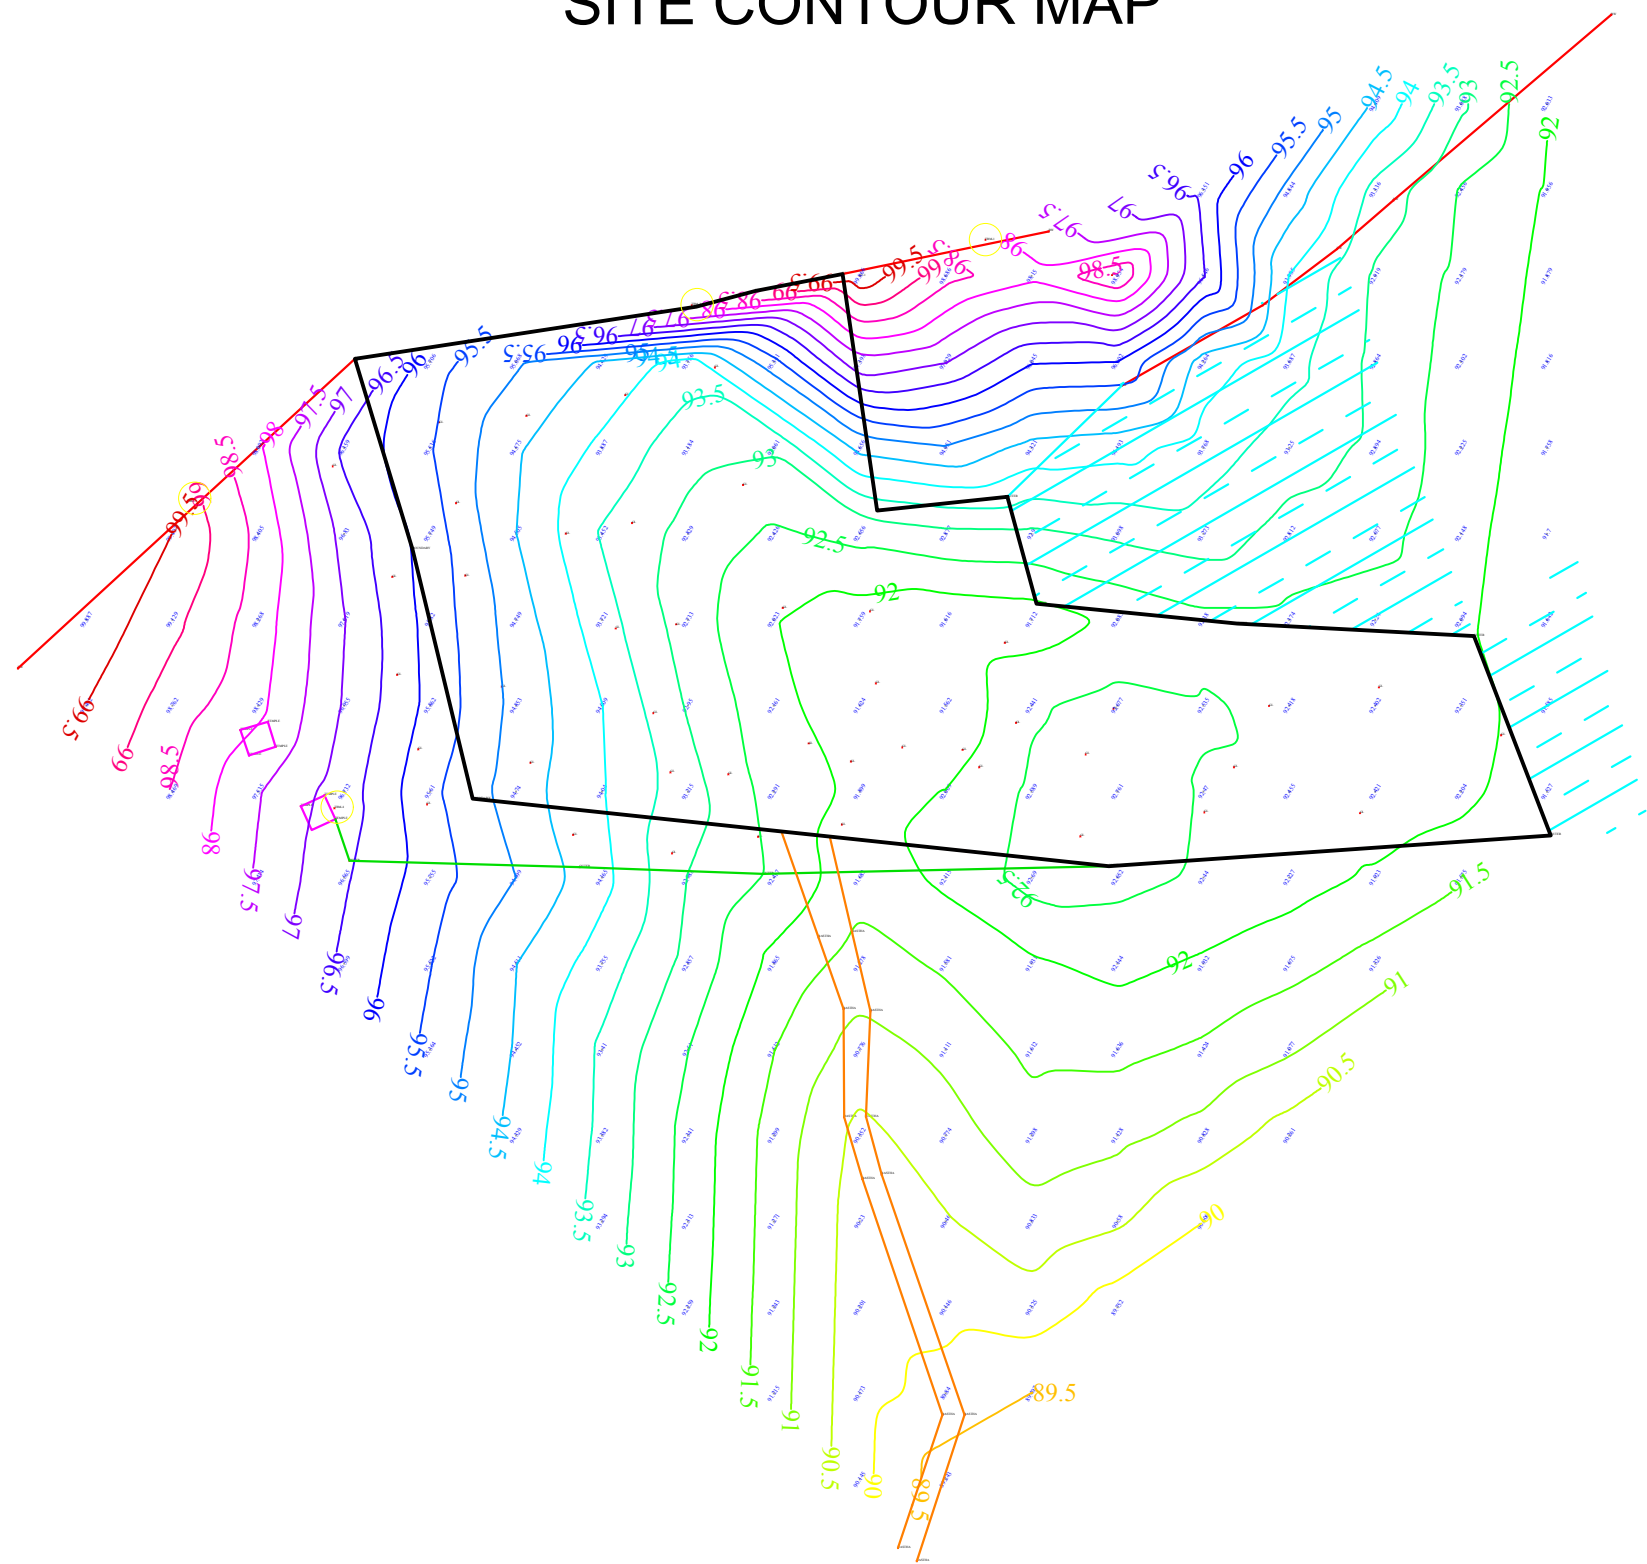

General Notes

LEGEND

	BUILDING
	COMPOUND WALL
	IN STONE
	BT ROAD
	J DA PILLAR
	TIE WELL
	TEMPLE
	TIE PUMP
	TELEPHONE POLE
	ELECTRIC POLE
	WIND PUMP
	CULVERT
	WATER TANK
	RLY LINE
	WIRE FENCING
	TREE
	L.T. LINE
	H.T. LINE

NOTES:
1. All dimensions are in meters.
2. The contour interval is 0.5 meters.
3. The map is based on the survey data of 2020.

DESIGNED BY:
MEGHNAJ CONSTRUCTION

77A, Usha Vihar, Tiruvani Nagar,
Gopalpur by Pass, Jaipur
Mob. : 91-7742055777

DATED:
2020

SCALE:
1:1000

DRAWING TITLE:
Faecal Sludge Treatment Plant, Khandela, Rajasthan

PROJECT:
Capacity Building Support for Innovative Sanitation Solution for Rajasthan

DRAWING NO.:
BMGF/Khandela/D-CONTOUR-20

SCALE: NTS

NOTE:
This drawing is indicative and for bidding purpose only

CLIENTS:
Rajasthan Urban Infrastructure Development
Project



CONSULTANT:
IPE Global
Limited



IPE Global House
B-84, Defence Colony,
New Delhi - 110 024
Tel. +91 11 4075 5900
Email: ipe@ipeglobal.com
www.ipeglobal.com

SUB CONSULTANT:
CDD Society



Survey No.205 ,Opp.
Beedi Workers Colony,
Kommaghatta Road,
Bandemath, Kengeri
Satellite Town,
Bengaluru, Karnataka
560060

